



SCREENED PORCH ELECTRICAL PLAN

0 4 8 12
SCALE: 1/4" = 1'-0"

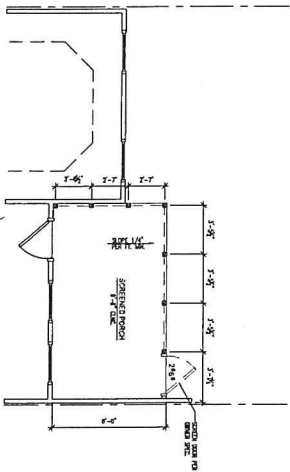

SCREENED PORCH FLOOR PLAN

0 4 8 12
SCALE: 1/4" = 1'-0"

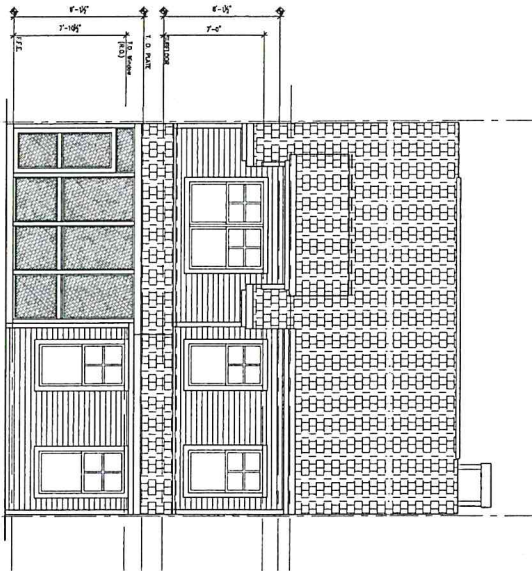

REAR ELEVATION

0 4 8 12
SCALE: 1/4" = 1'-0"



JOB START DESCRIPTION	
DATE	DATE
DESCRIPTION	LOCATION
NOTE	

DATE 3/28/18
PROJECT NO. 2018-93
SHEET NUMBER
3.3

LINDERBERG
SCREENED PORCH
OPTIONS

DATE	REVISION #	UPDATED BY:

D·R·HORTON **PHI**
America's Builder **NYSE**


Copyright 2010, All Rights Reserved

URBAN

ARCHITECTURAL GROUP
704 Kell Street, Suite 100
Charlotte, NC 28202
704.375.1100
www.urbanarchitect.com


FIRST FLOOR PLAN

SCALE 1/4" = 1'-0"

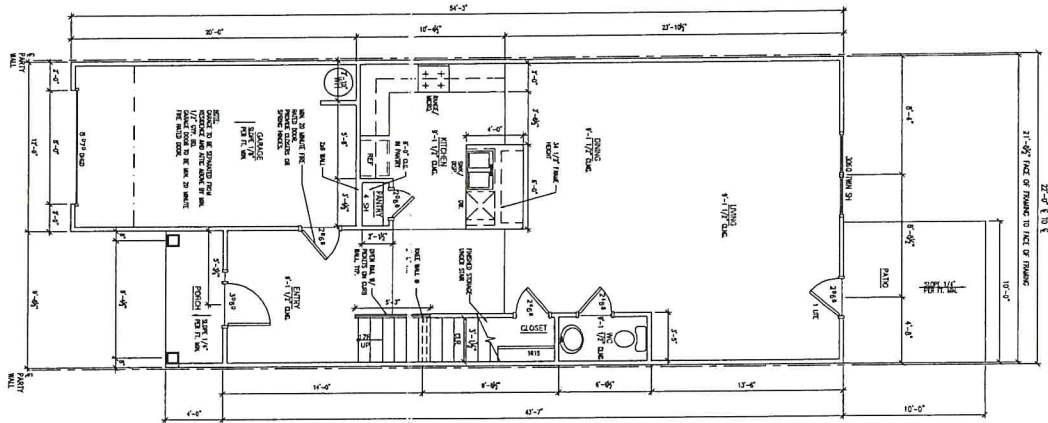


M. BATH OPTION

SCALE 1/4" = 1'-0"

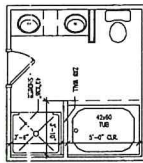

SECOND FLOOR PLAN

SCALE 1/4" = 1'-0"

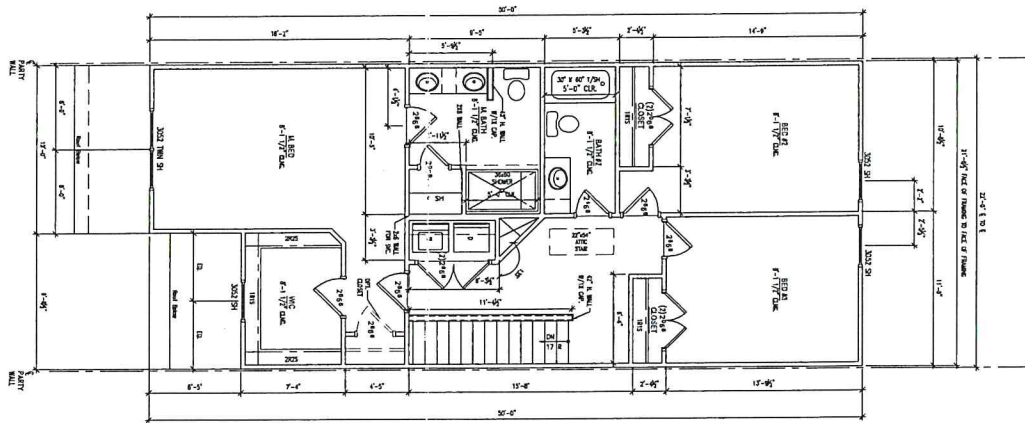

GENERAL NOTES AND LEGEND
1. ALL DIMENSIONS ARE IN FEET AND INCHES
2. ALL DIMENSIONS TO FACE UNLESS NOTED OTHERWISE
3. ALL WORK TO BE DONE IN ACCORDANCE WITH THE 2018 INTERNATIONAL RESIDENTIAL CODE



JOB START DESCRIPTION
PROJECT NO. 2018-03
DATE 12/21/18
DESIGNER 12/21/18
DATE 12/21/18
DATE 12/21/18

3.1

FIRST AND SECOND FLOOR PLANS


AVIATOR

D.R. HORTON PHILLYSE
America's Builder

Copyright 2010, All Rights Reserved


704. 441.1232
1112 S.W. 5th Ave., Suite 1100
Miami, FL 33135
www.urbanarchitecturalgroup.com



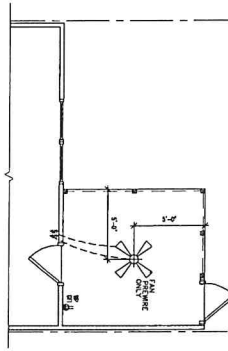


SCREENED PORCH ELECTRICAL PLAN

0 4 8 12
SCALE: 1/4" = 1'-0"

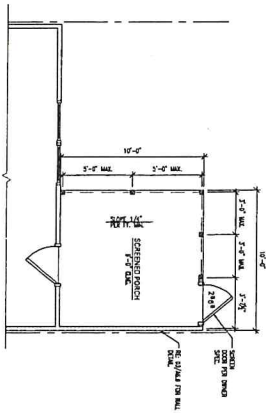

SCREENED PORCH FLOOR PLAN

0 4 8 12
SCALE: 1/4" = 1'-0"

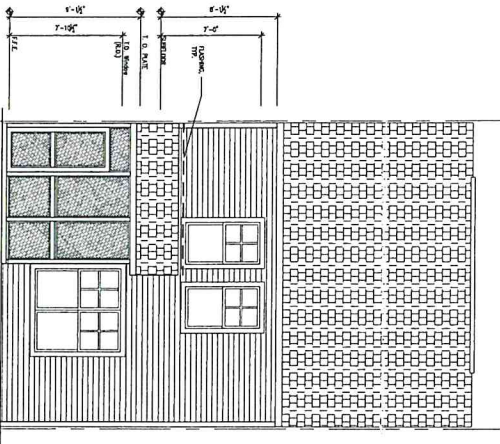

REAR ELEVATION

0 4 8 12
SCALE: 1/4" = 1'-0"



JOB START DESCRIPTION	
DATE	12/21/18
DRAWN BY	101 R
CHECKED BY	101 R
DATE	

DATE: 12/21/18
PROJECT NO: 2016-01
SHEET NUMBER
3.2

SCREENED PORCH
OPTIONS


AVIATOR

DATE	REVISION #	UPDATED BY:

D·R·HORTON
America's Builder

Copyright 2010, All Rights Reserved

URBAN
ARCHITECTURAL GROUP
1614 South Street
Charlotte, NC 28203
704.341.1399
www.urbanarchitect.com

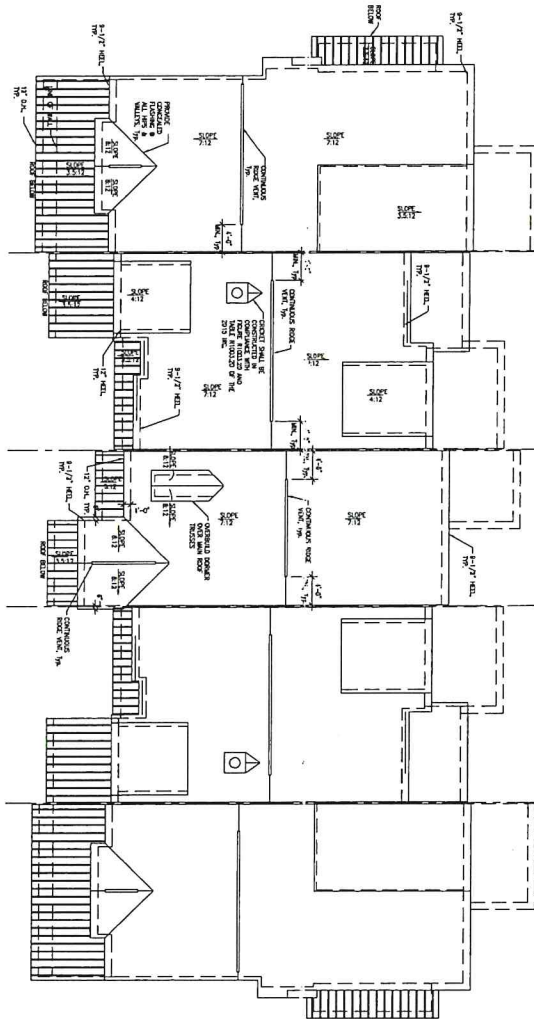

ROOF PLAN
SCALE: 1/8" = 1'-0"

NOTE: PLANS ARE DISCUSSANTIC ONLY. REFER TO TRUSS CONSTRUCTION.

JOB START DESCRIPTION	
DESIGN BY:	DATE:
DATE:	DATE:
DATE:	DATE:



D.R. HORTON **PHI NYSE**
America's Builder

Copyright 2010, All Rights Reserved

URBAN
ARCHITECTURAL GROUP
1112 Main Street, Suite 200
Columbia, South Carolina 29201
Tel: 803.733.1111
Fax: 803.733.1112
www.urbanarchitect.com

BAREFOOT DYE
TOWNHOMES
5-UNIT BUILDING

ROOF PLAN

A4.1

[illegible]

DATE: 3/28/18
PROJECT NO: 2016-33
SHEET NUMBER: 4.1

KITTY HAWK


DATE	REVISION #	UPDATED BY:
------	------------	-------------

D·R·HORTON **DHI**
NYSE
America's Builder

Copyright 2010, All Rights Reserved



ARCHITECTURAL GROUP
841.1839 M 1142 Wilson Drive Suite 200
704 841.8440 W Matthews, North Carolina 27603
www.aaacorp.com

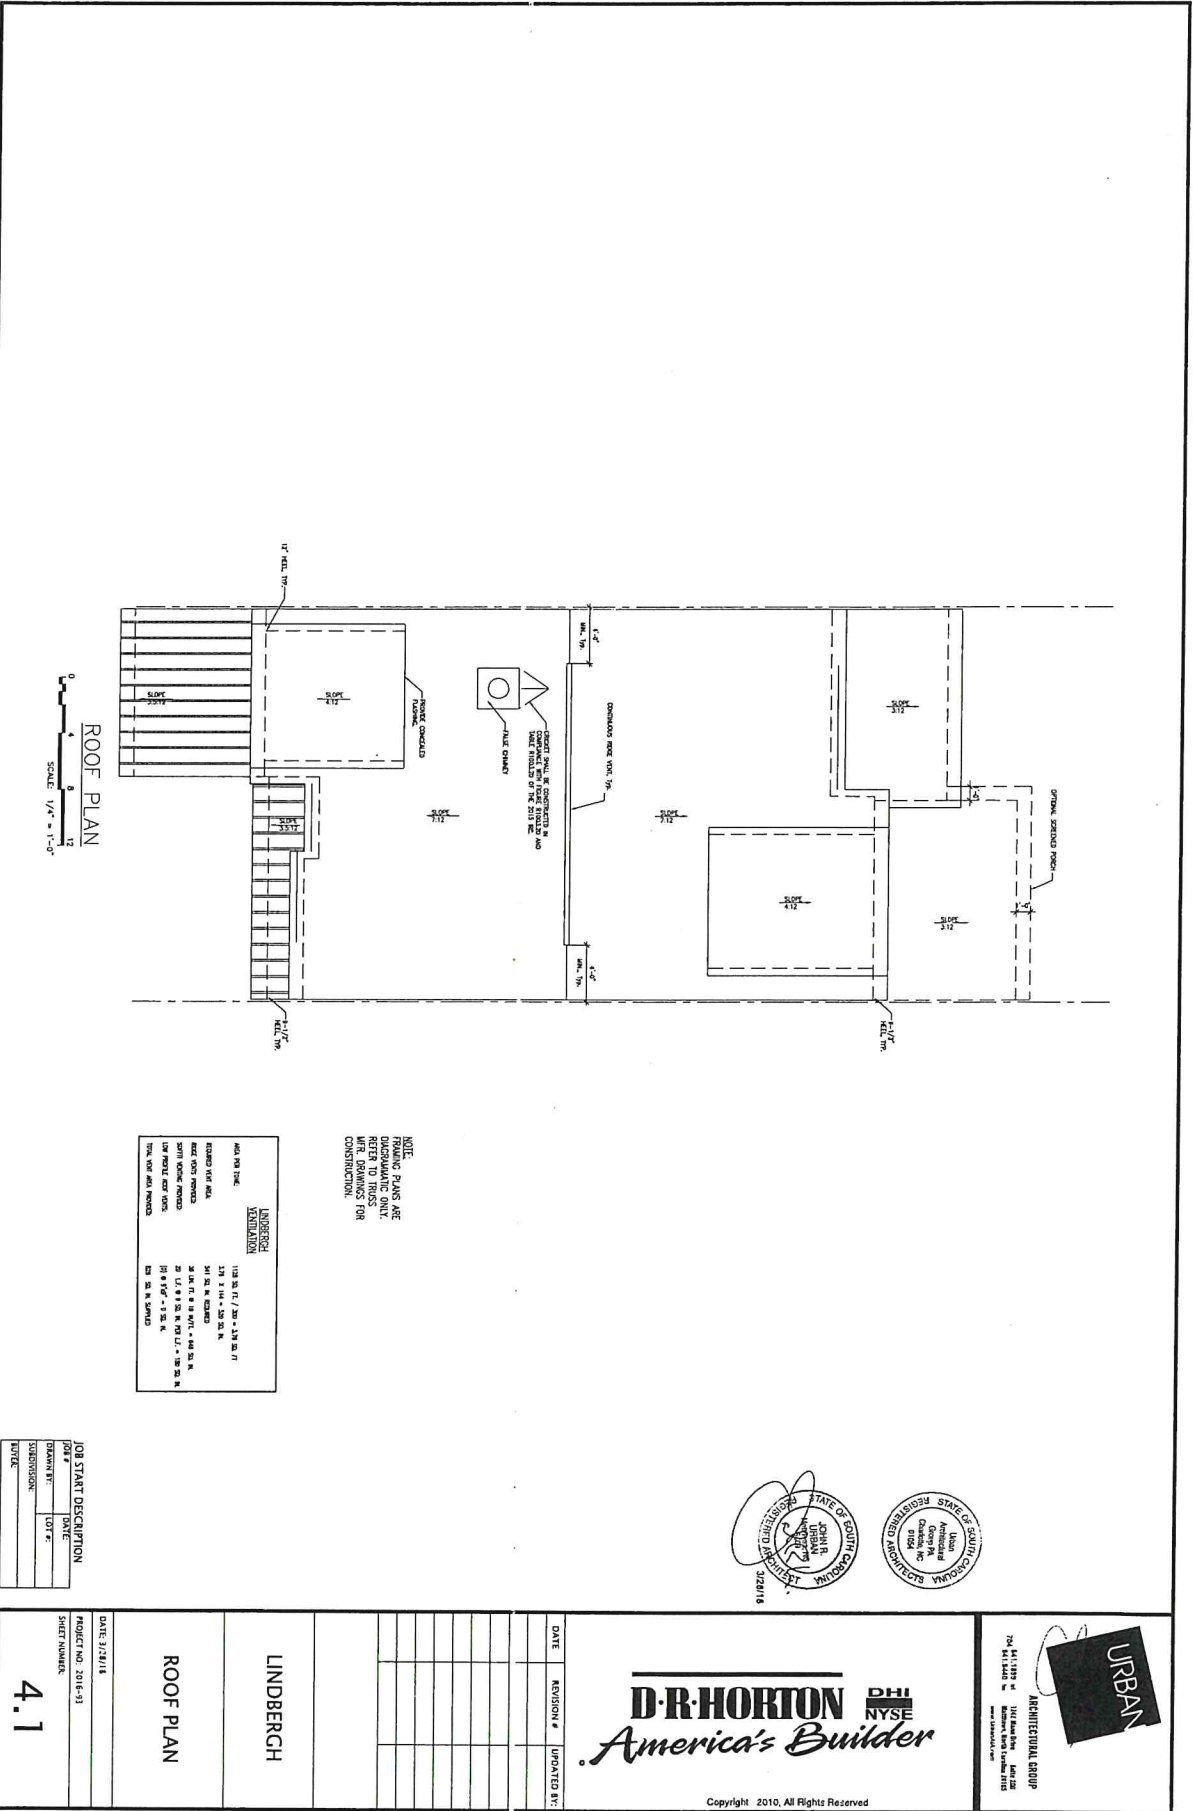


JOB START DESCRIPTION	
DATE	12/20/16
PROJECT NO.	2016-13
SHEET NUMBER	4.1

DATE	12/20/16
PROJECT NO.	2016-13
SHEET NUMBER	4.1


LINDERBERG EXAMINATION	
DATE	12/20/16
PROJECT NO.	2016-13
SHEET NUMBER	4.1

NOTE:
FINISHING PLANS ARE
DISSEMINATING ONLY.
THESE PLANS ARE NOT
TO BE USED FOR
CONSTRUCTION.

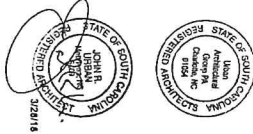

D-R HORTON
America's Builder



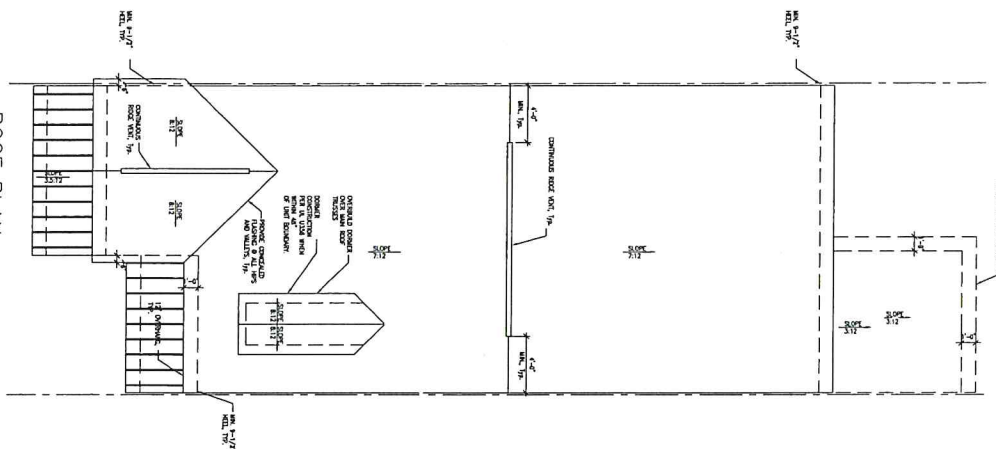

ROOF PLAN



0 4 8 12

SCALE: 1/4" = 1'-0"

NOTE:
FRAMING PLANS ARE
DIAGRAMATIC ONLY.
REFER TO TRUSS
WFR DRAWINGS FOR
CONSTRUCTION.

[illegible]


JOB START DESCRIPTION	
JOB #	DATE
DRAWN BY:	LOT #:
SUBDIVISION:	
BUYER:	

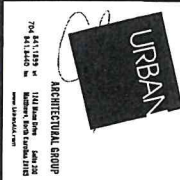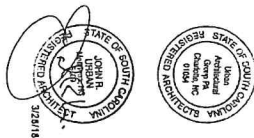[illegible]

D·R·HORTON DHI
NYSE
America's Builder

Copyright 2010. All Rights Reserve

ELECTRICAL PLAN	
SYMBOLS	
	SWITCH, SINGLE POLE
	SWITCH, 4-WIRE
	RECEPTICAL, STANDARD OUTLET
	RECEPTICAL, 30 OR 60 AMP
	RECEPTICAL, 30 OR 60 AMP, 4-WIRE
	WATER METER
	RADIATOR
	RADIATOR, 200 BTU
	RADIATOR, 400 BTU
	RADIATOR, 600 BTU
	RADIATOR, 17800 BTU
	RADIATOR

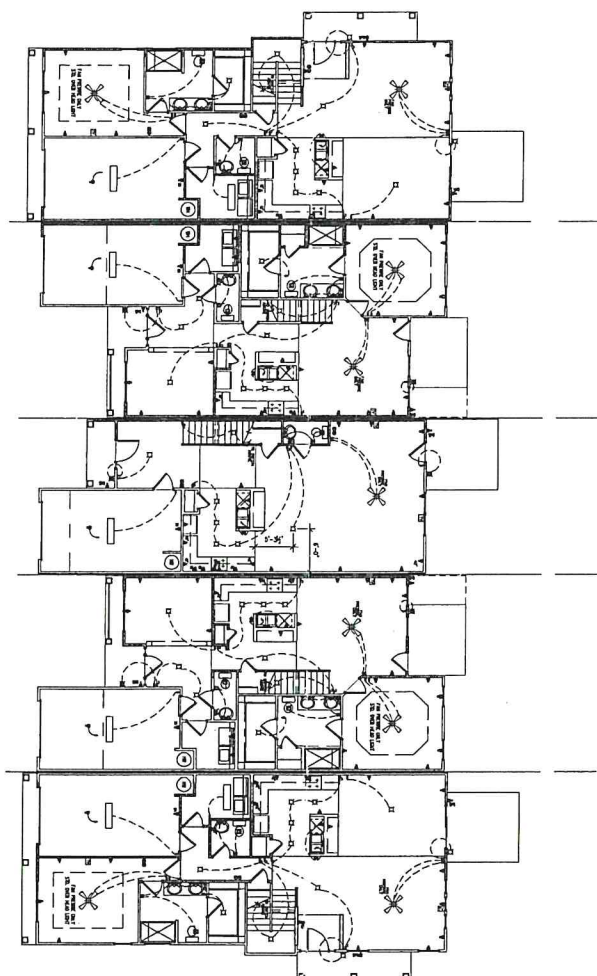

FIRST FLOOR PLAN

SCALE: 1/8" = 1'-0"

JOB START DESCRIPTION	
JOB #	DATE:
DRAWN BY:	LOT #:
SUBDIVISION:	
BUYER:	

[illegible]

D·R·HORTON 
America's Builder


Copyright 2010, All Rights Reserved



UNLESS OTHERWISE NOTED, INSTANT SWITCHES AND
FLOOR PLATES AT THE FOLLOWING HEIGHTS ABOVE FINISH
FLOOR SHALL BE USED: 4'-0" TO 4'-6" FOR SWITCHES
AND 4'-0" TO 4'-6" FOR FLOOR PLATES.

ELECTRICAL PLAN

- SYMBOLS**
- 1. SWITCH, 3-WAY
 - 2. SWITCH, 4-WAY
 - 3. SWITCH, 4-WAY
 - 4. SWITCH, 4-WAY
 - 100. SWITCH, 4-WAY

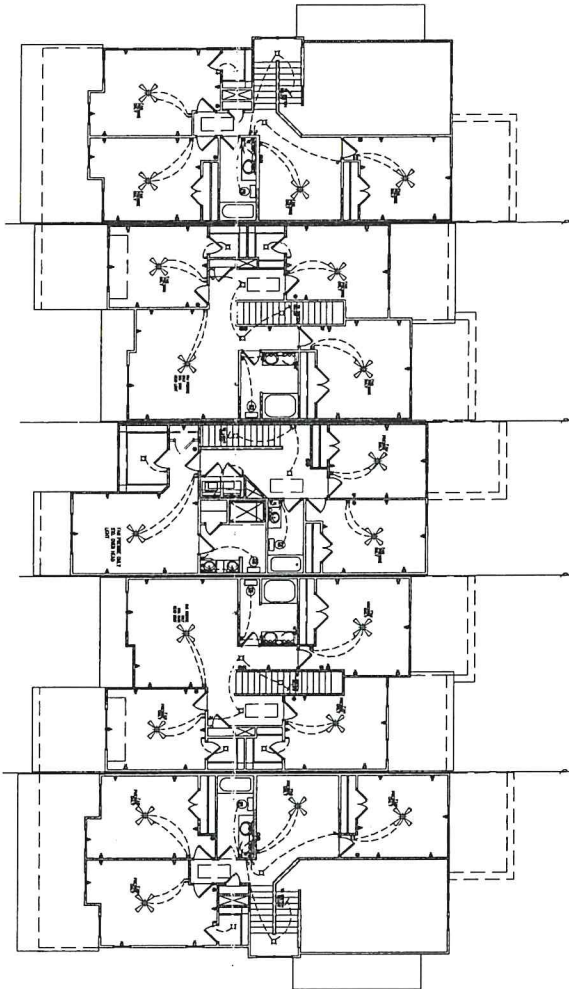

SECOND FLOOR PLAN

SCALE: 1/8" = 1'-0"

DATE	DESCRIPTION
2010-01-15	ISSUED FOR PERMIT
2010-01-15	ISSUED FOR CONSTRUCTION
2010-01-15	ISSUED FOR RECORD

DATE	REVISION #	DESCRIPTION
2010-01-15	1	ISSUED FOR PERMIT
2010-01-15	2	ISSUED FOR CONSTRUCTION
2010-01-15	3	ISSUED FOR RECORD

 


D-R HORTON
America's Builder

URBAN
ARCHITECTURAL GROUP
1111 11th Ave. S.
Nashville, TN 37203
615.259.1111
www.urbanarchitect.com

OUTLETS _____ +14°
 TUBS _____ +14°
 TILTING _____ +11°
 OUTLETS (COLD) _____ +40°
 KITCHEN OUTLETS _____ +40°



\$ SWITCH SINGLE POLE
\$³ SWITCH 3-WAY



JOB START DESCRIPTION	
JOB #	DATE:
DIAMN BY:	LOT #:
SUBDIVISION:	
BUYER:	

		
DATE: _____ REVISION #: _____ UPDATED BY: _____		
PROJECT NO: 2016-91		
SHEET NUMBER: 6.1		

ELECTRICAL PLAN
SYMBOLS

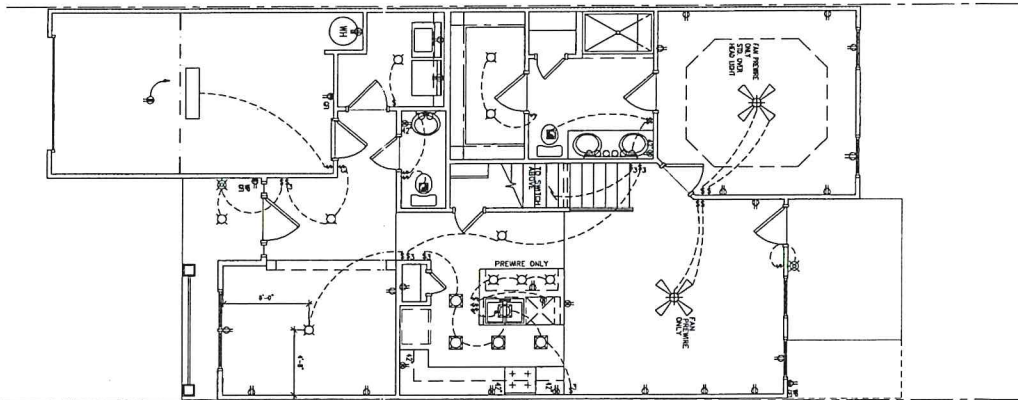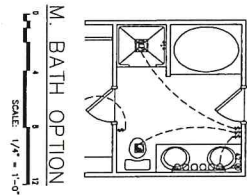

FIRST FLOOR PLAN

0 4 8 12
SCALE: 1/4" = 1'-0"

JOB START DESCRIPTION	
JOB #	DATE
DMANN RT	LOT #
SUBDIVISION:	
ROUTE:	

ELECTRICAL
PLAN

DATE: 3/28/18

PROJECT NO: 2016-03

SHEET NUMBER:

6.1

LINDERBERGH

ELECTRICAL PLAN

6.1

DATE	
REVISION #	
UPO	



D·R·HORTON **DHI**
NYSE

America's Builder

Copyright 2010, All Rights Reserved



URBAN

ARCHITECTURAL GROUP

1142 West 41st St. • Suite 202
 Madison, WI 53704 414.778.1111
www.urbanad.com

UNLESS OTHERWISE NOTED, INSTALL SWITCHES AND RECEPTACLES AT THE FOLLOWING HEIGHTS ABOVE FINISH FLOOR TO THE BOTTOM OF BOX AND RECEPTACLE:

SWITCHES _____ 4'-0"

RECEPTACLES _____ 1'-6"

TELEPHONE _____ 1'-0"

OUTLETS (GANG) _____ 1'-0"

EXPOSED OUTLETS _____ 1'-0"

ELECTRICAL PLAN

- SYMBOLS**
- 1. SWITCH, SINGLE POLE
 - 2. SWITCH, 3-WAY
 - 3. SWITCH, 4-WAY
 - 4. RECEPTACLE, SHROUD BOX
 - 5. RECEPTACLE ON 20 AMP CIRCUIT
 - 6. RECEPTACLE ON 15 AMP CIRCUIT
 - 7. RECEPTACLE, 20 AMP
 - 8. RECEPTACLE, 15 AMP
 - 9. RECEPTACLE, 15 AMP
 - 10. RECEPTACLE, 15 AMP
 - 100. RECEPTACLE, 15 AMP

MASTER SUITE OPTION

SCALE: 1/4" = 1'-0"

SECOND FLOOR PLAN - STANDARD

SCALE: 1/4" = 1'-0"

BATH 3 / BED 5 OPTION

SCALE: 1/4" = 1'-0"

JOB START DESCRIPTION	
DATE	10/1/11
PROJECT NO.	2011-13
SHEET NUMBER	6.2
DATE	10/1/11
PROJECT NO.	2011-13
SHEET NUMBER	6.2



D.R. HORTON PHI NYSE
America's Builder

Copyright 2010, All Rights Reserved




704 S. 1st St.
Tomball, TX 77375
281.346.1111
www.urbanarchitect.com

JOB START DESCRIPTION	
DATE	10/1/11
PROJECT NO.	2011-13
SHEET NUMBER	6.2
DATE	10/1/11
PROJECT NO.	2011-13
SHEET NUMBER	6.2

OUTLETS.....+16°
TILTING.....+11°
TILTING.....+11°
OUTLETS (CANALS).....+45°
KITCHEN OUTLETS.....+45°

ELECTRICAL PLAN
SYMBOLS

- | | |
|---|-------------------|
|  | 3/4" NPT, 90° ELB |
|  | 3/4" NPT, TEE |
|  | 3/4" NPT, TEE |
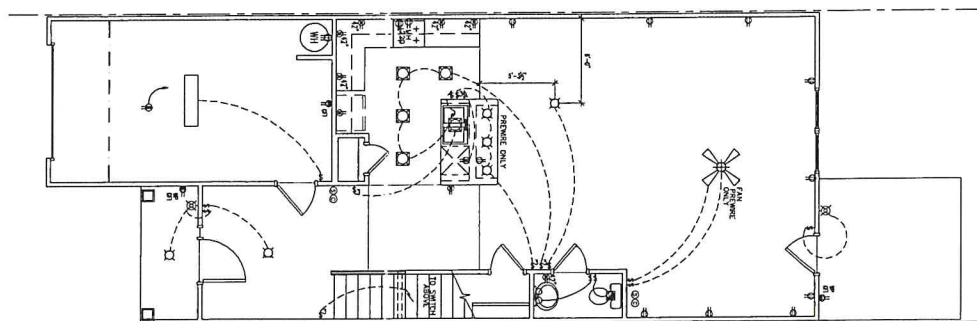


FIRST FLOOR



0 4 8 12

SCALE: 1/4" = 1'-0"


The first floor plan shows a rectangular building with a central corridor. The corridor is 4 feet wide and runs the full length of the building. On either side of the corridor are rooms. The rooms on the left are 4 feet wide, and the rooms on the right are 8 feet wide. The total width of the building is 12 feet. The total length of the building is 12 feet. The plan is drawn at a scale of 1/4 inch = 1 foot.

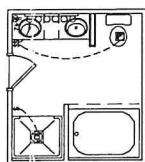

M. BATH OPTION

0 4 8 12


SCALE: 1/4" = 1'-0"

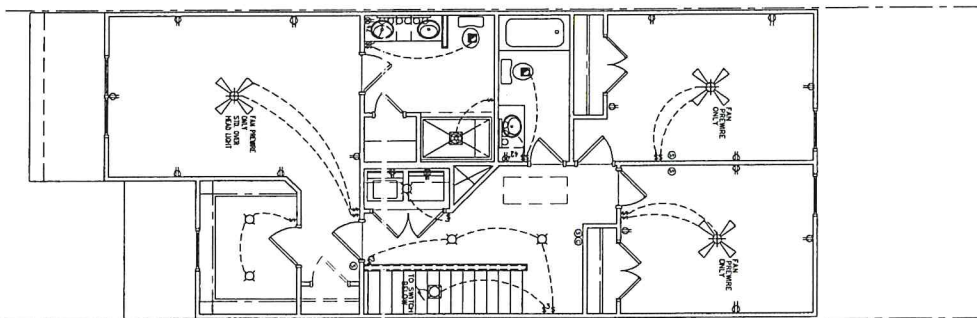

SECOND FLOOR


0 4 8 12

SCALE: 1/4" = 1'-0"

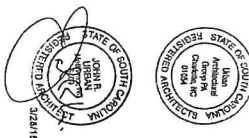


JOB START DESCRIPTION	
JOB #	DATE
DRAWN BY:	LOT #:
SUBDIVISION	
SHEET:	

[illegible]

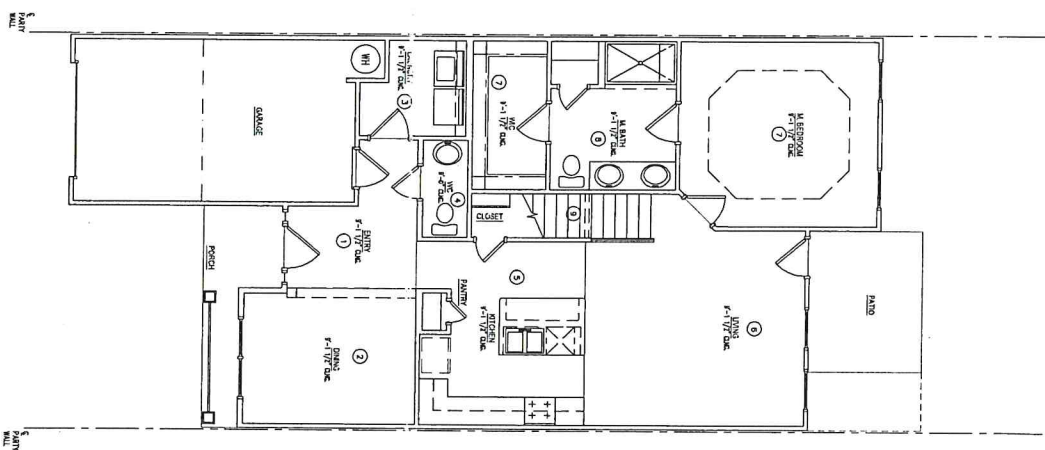

FIRST FLOOR PLAN

0 4 8 12
SCALE: 1/4" = 1'-0"

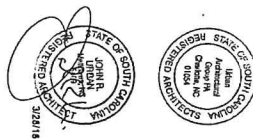

ARCHITECTURAL GROUP
841.1839 m
704 841.8443 m
1142 Main Drive Suite 202
Midtown, North Carolina 27511
www.lisaarch.com

D·R·HORTON 
America's Builder

Copyright 2010, All Rights Reserved

DATE	REVISION #	UPDATED BY

[illegible]

LINDBERGH

FIRST FLOOR
COVERING

JOB START DESCRIPTION	
JOB #	DATE:
DRAWN BY:	LOT #:
SUBDIVISION:	
SHEET:	

7.1