


UNLESS OTHERWISE NOTED, INSTALL SWITCHES AND
FLOOR TO THE BOTTOM OF BOX AND RECEPTACLE
SNITCH _____ 4'-0"
TURNOUT _____ 1'-0"
TUBES _____ 1'-0"
RECEPTACLE _____ 1'-0"
RECEPTACLE _____ 1'-0"

ELECTRICAL PLAN

- SYMBOLS**
- 1. SNITCH, SINGLE POLE
 - 2. SNITCH, 3-WAY
 - 3. SNITCH, 4-WAY
 - 4. RECEPTACLE, STANDARD
 - 5. RECEPTACLE, 20 AMP
 - 6. RECEPTACLE, 20 AMP, 125V
 - 7. RECEPTACLE, 20 AMP, 125V, 125V
 - 8. RECEPTACLE, 20 AMP, 125V, 125V
 - 9. RECEPTACLE, 20 AMP, 125V, 125V
 - 100. RECEPTACLE, 20 AMP, 125V, 125V

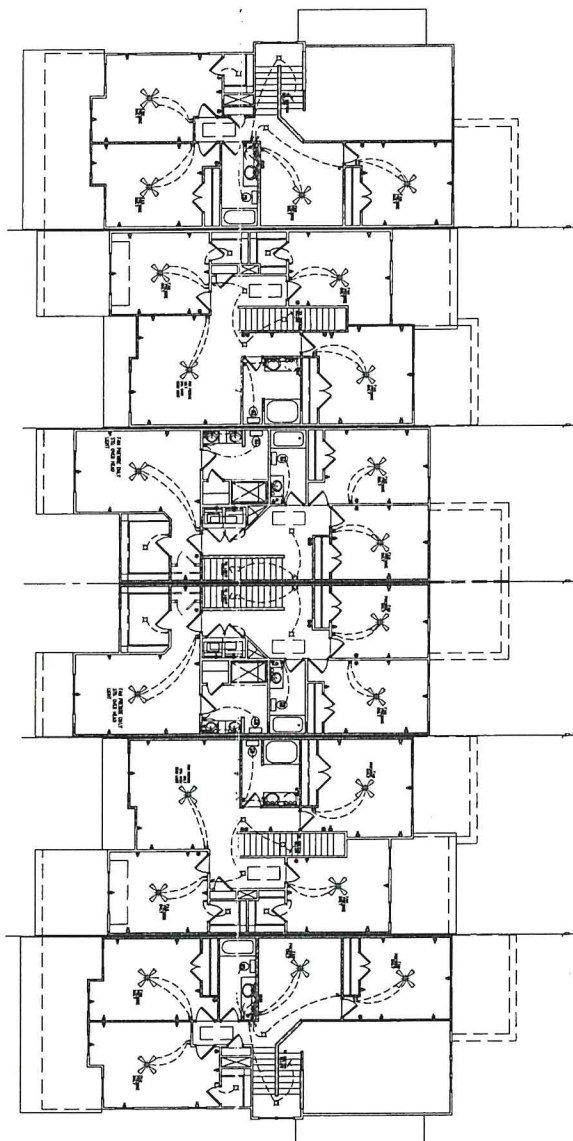

SECOND FLOOR PLAN

SCALE: 1/8" = 1'-0"

JOB STAT DESCRIPTION	
DATE	
BY	
REVISION	
DATE	
BY	
REVISION	

DATE: 3/2/11
PROJECT NO: 2011-01
SHEET NUMBER: A5.2

BAREFOOT DYE
TOWNHOMES
6-UNIT BUILDING

SECOND FLOOR
ELECTRICAL

DATE	REVISION #	UPDATED BY

D.R. HORTON **PHI**
America's Builder **NYSE**

Copyright 2010, All Rights Reserved


URBAN
ARCHITECTURAL GROUP

704-441-1339
1414 South Blvd., Suite 200
Fort Lauderdale, FL 33304

OULTS _____ +14°
 BALMORH _____ +14°
 MILNORH _____ +14°
 OULTS (CROSS) _____ +46°
 KIRKEN OULTS _____ +46°


ELECTRICAL PLAN SYMBOLS

- | | |
|---|-------------------|
|  | SCREW, SMALL FLAT |
|  | SCREW, 1-WAY |
|  | SCREW, 1-WAY |
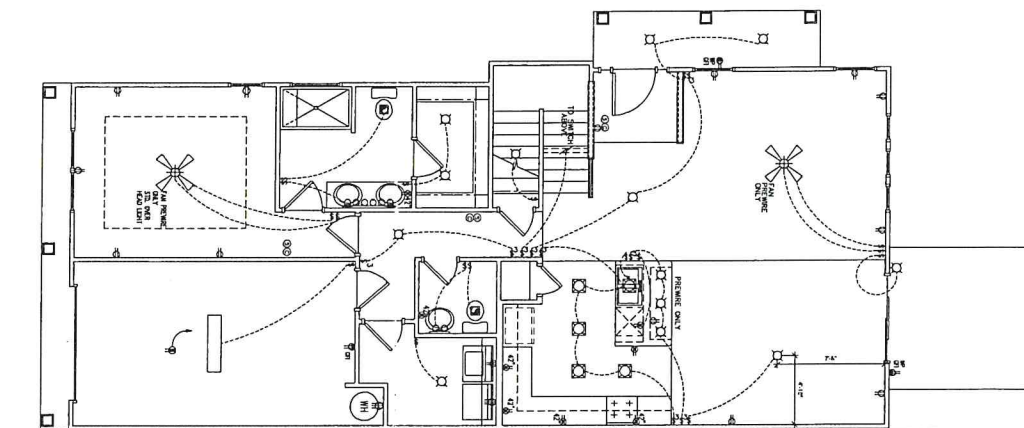


FIRST FLOOR

SCALE: 1/4" = 1'-0"

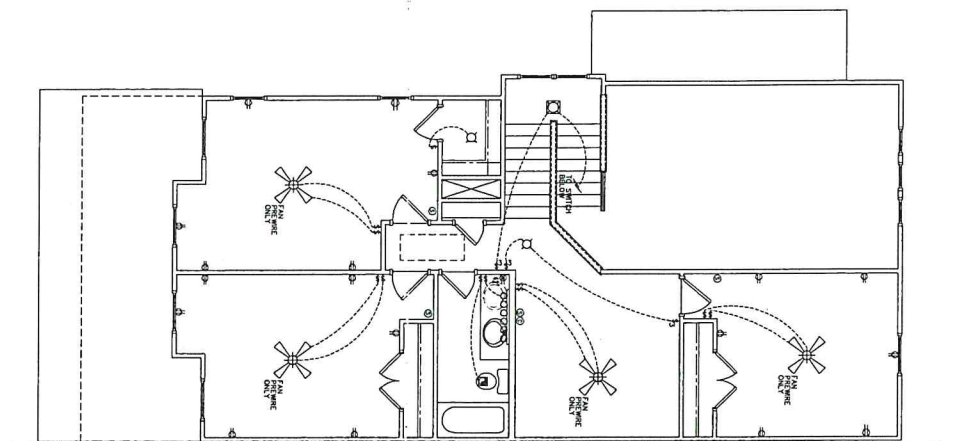


SECOND FLOOR

SCALE: 1/4" = 1'-0"

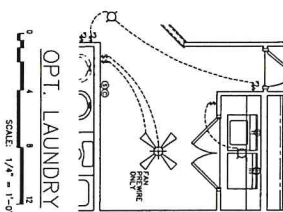

OPT. LAUNDRY

SCALE: 1/4" = 1'-0"

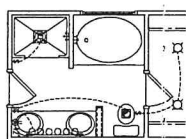

M. BATH OPTION

SCALE: 1/4" = 1'-0"



ARCHITECTURAL GROUP
 841.1835 W 704
 841.8443 W 704
 1144 Main Drive, Suite 228
 Madison, North Carolina 27125
 704.241.1835

D·R·HORTON **DHI**
America's Builder **NYSE**

Copyright 2010, All Rights Reserved

[illegible]

KITTY HAWK

ELECTRICAL
PLANS

6.1


JOB START DESCRIPTION	
JOB #	DATE:
DRAWN BY:	LOT #:
SUBDIVISION:	
BUYER:	

UNLESS OTHERWISE NOTED, INSTALL SWITCHES AND RECEPTS AT THE FOLLOWING HEIGHTS ABOVE FINISH FLOOR TO THE BOTTOM OF BOX AND INSET MODEL.


- SWITCHES: 4'-0"
- RECEPTS: 1'-6"
- DATA OUTLETS: 4'-0"
- TELEPHONE: 4'-0"
- TELEVISION: 4'-0"
- VIDEO: 4'-0"

ELECTRICAL PLAN SYMBOLS


- 1. SWITCH, SINGLE POLE
- 2. SWITCH, 3-WAY
- 3. SWITCH, 4-WAY
- 4. RECEPT, STANDARD OUTLET
- 5. RECEPT, ON 60 CIRCUIT
- 6. RECEPT, ON 60 CIRCUIT & 4"
- 7. RECEPT, ON 60 CIRCUIT & 4"
- 8. RECEPT, ON 60 CIRCUIT & 4"
- 9. RECEPT, 200V
- 10. RECEPT, 200V, 1/2" SWITCH
- 11. RECEPT, 100V, 1/2" SWITCH
- 12. RECEPT, 100V, 1/2" SWITCH
- 13. RECEPT, 100V, 1/2" SWITCH
- 100. RECEPT, 100V, 1/2" SWITCH

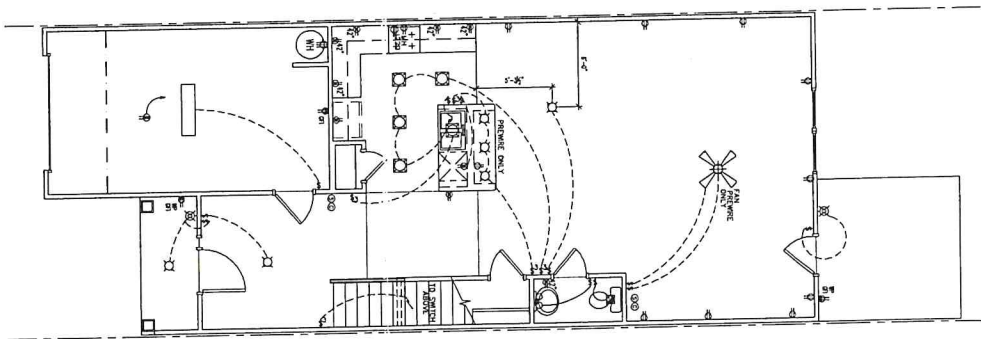

FIRST FLOOR
SCALE: 1/4" = 1'-0"

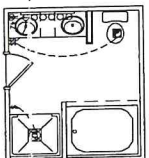

M. BATH OPTION
SCALE: 1/4" = 1'-0"

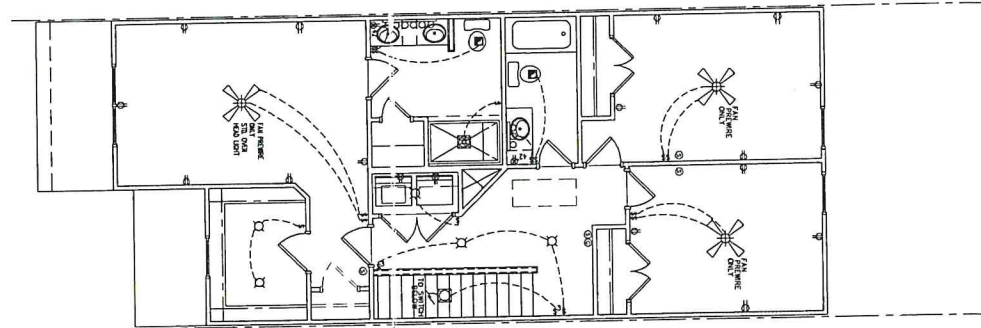

SECOND FLOOR
SCALE: 1/4" = 1'-0"

JOB START DESCRIPTION	DATE
PROJECT NO. 2016-91	
DRAWING NO. 6.1	
REVISION	
DATE	



URBAN
ARCHITECTURAL GROUP
704 S. 10TH ST. SUITE 200
DENVER, CO 80202
303.733.1111
www.urbandesign.com

D.R. HORTON NYSE LISTED
America's Builder

Copyright 2010, All Rights Reserved

DATE: 3/12/16
REVISION #
UPDATED BY:
PROJECT NO. 2016-91
SHEET NUMBER
6.1



PROJECT NO: 2016-93
SHEET NUMBER:
7.1


FIRST FLOOR
COVERING

KITTY HAWK

[illegible]


D·R·HORTON **DHI**
NYSE
America's Builder

Copyright 2010. All Rights Reserved

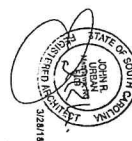

ARCHITECTURAL GROUP

641.1833 m 1142 Main Drive Suite 220
704 641.8440 tw Waltham, North Carolina 27178
www.lhsarchitect.com

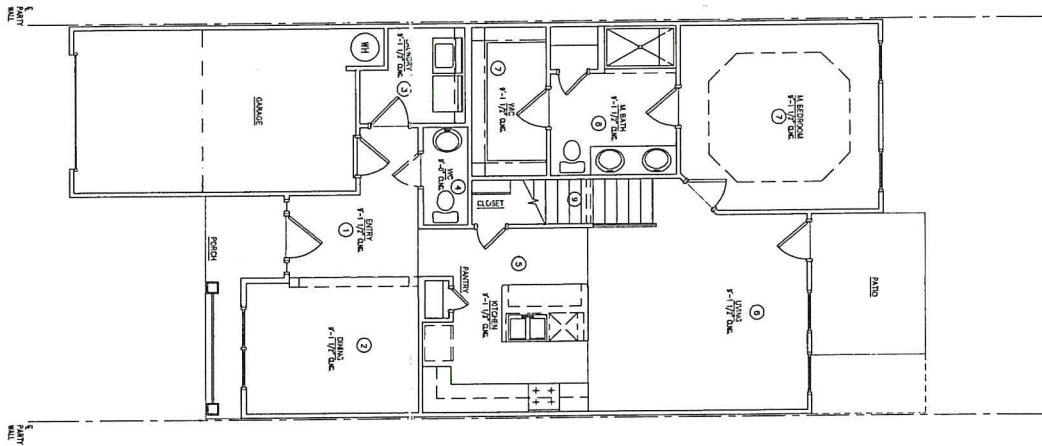

FIRST FLOOR PLAN

0 4 8 12

SCALE: 1/4" = 1'-0"




D·R·HORTON **DHI**
NYSE
America's Builder


Copyright 2010, All Rights Reserved

JOB START DESCRIPTION	
JOB #	DATE:
DRAWN BY:	LOT #:
SUBDIVISION:	
SHEET:	


[illegible]

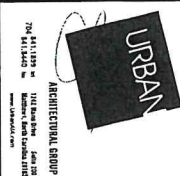



FIRST FLOOR PLAN

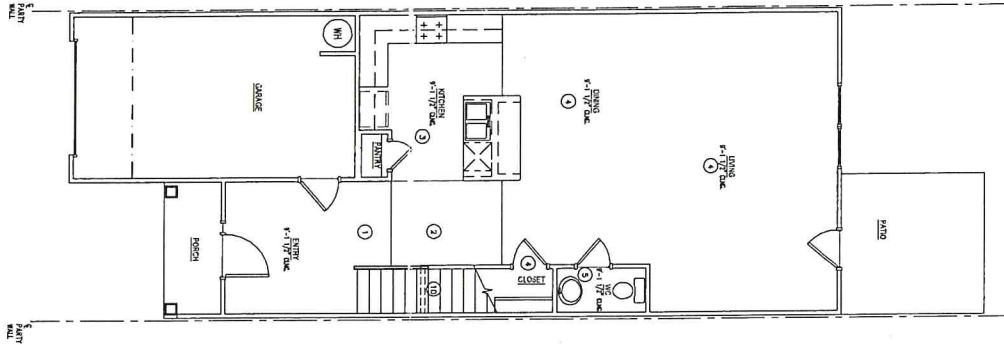

M. BATH OPTION

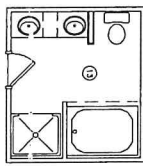

SECOND FLOOR PLAN

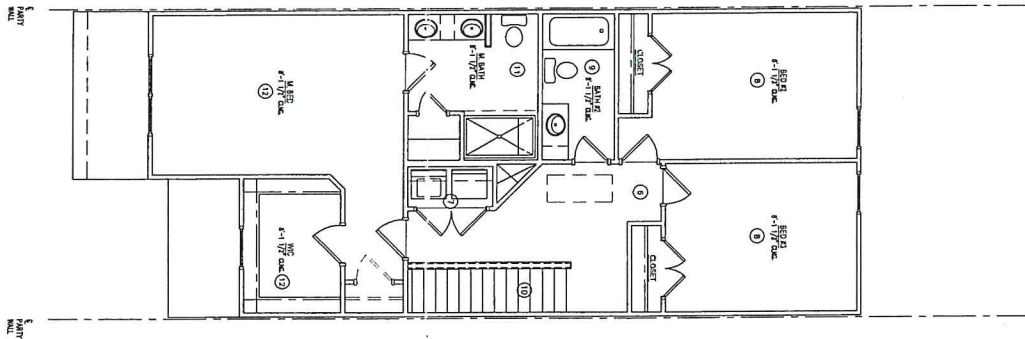 

JOB STAT DESCRIPTION	
DATE	10/1/11
DESIGNER	DATE
REVISION	DATE

7.1

FIRST AND SECOND FLOOR COVERING

AVIATOR


DATE	REVISION #	UPDATED BY

D.R. HORTON **DH NYSE**
America's Builder

Copyright 2010, All Rights Reserved

URBAN
ARCHITECTURAL GROUP
704 441-1999
1010 New York Ave. Ste. 200
New York, NY 10003-1003

BAREFOOT DYE TOWN HOMES

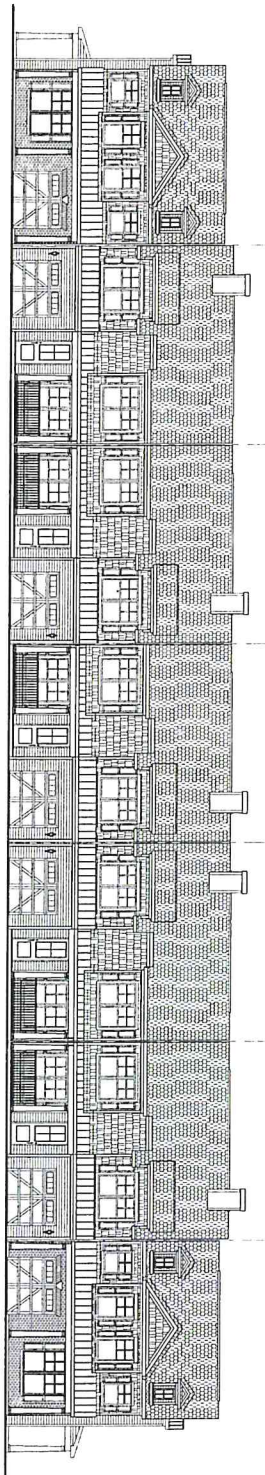

7-UNIT BUILDING

KITTY HAWK AREA TABULATION

HEATED FIRST FLOOR	1927
HEATED SECOND FLOOR	913
TOTAL HEATED AREAS	2739
GLAZED	243
GLAZED PORCH	57
SCREENED PORCH	48
REAR PORCH	160
STORAGE	0
TOTAL UNHEATED ROOF - STANDARD	2259
OPTIONAL SCREEN PORCH	112
TOTAL UNHEATED ROOF - TOTAL	2371

NOTE: THIS TABULATION IS FOR THE STANDARD BUILDING. IF YOU WANT TO ADD A SCREEN PORCH, ADD 112 TO THE TOTAL UNHEATED ROOF.

LINDERBERG AREA TABULATION

HEATED FIRST FLOOR	1640
HEATED SECOND FLOOR	1640
TOTAL HEATED AREAS	3280
GLAZED	243
GLAZED PORCH	57
SCREENED PORCH	77
STORAGE	0
TOTAL UNHEATED ROOF - STANDARD	2479
OPTIONAL SCREEN PORCH	111
TOTAL UNHEATED ROOF - TOTAL	2590

NOTE: THIS TABULATION IS FOR THE STANDARD BUILDING. IF YOU WANT TO ADD A SCREEN PORCH, ADD 111 TO THE TOTAL UNHEATED ROOF.

ARCHITECTURAL SHEET INDEX


- 401 COVER SHEET
- 402 ELEVATIONS
- 403 ELEVATIONS
- 404 ELEVATIONS
- 500 ELEVATIONS

CODE REVIEW

- SECTION 1.01: GENERAL NOTES
- SECTION 1.02: FOUNDATIONS
- SECTION 1.03: FLOORING
- SECTION 1.04: ROOFING
- SECTION 1.05: EXTERIOR FINISHES
- SECTION 1.06: INTERIOR FINISHES
- SECTION 1.07: MECHANICAL, ELECTRICAL, AND PLUMBING
- SECTION 1.08: PAINTS AND COATINGS
- SECTION 1.09: SPECIALTIES
- SECTION 1.10: EQUIPMENT
- SECTION 1.11: FURNITURE
- SECTION 1.12: LANDSCAPE ARCHITECTURE
- SECTION 1.13: SIGNAGE
- SECTION 1.14: ACCESSORIES
- SECTION 1.15: SCHEDULE
- SECTION 1.16: SPECIFICATIONS
- SECTION 1.17: NOTES
- SECTION 1.18: REVISIONS
- SECTION 1.19: INDEX
- SECTION 1.20: APPENDICES
- SECTION 1.21: GLOSSARY
- SECTION 1.22: BIBLIOGRAPHY
- SECTION 1.23: REFERENCES
- SECTION 1.24: CONTACTS
- SECTION 1.25: OTHER INFORMATION
- SECTION 1.26: LEGEND
- SECTION 1.27: SCALE
- SECTION 1.28: DATE
- SECTION 1.29: DRAWN BY
- SECTION 1.30: CHECKED BY
- SECTION 1.31: APPROVED BY
- SECTION 1.32: TITLE
- SECTION 1.33: PROJECT NO.
- SECTION 1.34: SHEET NO.
- SECTION 1.35: TOTAL SHEETS
- SECTION 1.36: CLIENT
- SECTION 1.37: ARCHITECT
- SECTION 1.38: ENGINEER
- SECTION 1.39: LANDSCAPE ARCHITECT
- SECTION 1.40: PLUMBER
- SECTION 1.41: ELECTRICIAN
- SECTION 1.42: MECHANICAL ENGINEER
- SECTION 1.43: FURNITURE DESIGNER
- SECTION 1.44: SIGNAGE DESIGNER
- SECTION 1.45: ACCESSORY DESIGNER
- SECTION 1.46: SCHEDULE DESIGNER
- SECTION 1.47: SPECIFICATIONS DESIGNER
- SECTION 1.48: NOTES DESIGNER
- SECTION 1.49: REVISIONS DESIGNER
- SECTION 1.50: INDEX DESIGNER
- SECTION 1.51: APPENDICES DESIGNER
- SECTION 1.52: GLOSSARY DESIGNER
- SECTION 1.53: BIBLIOGRAPHY DESIGNER
- SECTION 1.54: REFERENCES DESIGNER
- SECTION 1.55: CONTACTS DESIGNER
- SECTION 1.56: OTHER INFORMATION DESIGNER
- SECTION 1.57: LEGEND DESIGNER
- SECTION 1.58: SCALE DESIGNER
- SECTION 1.59: DATE DESIGNER
- SECTION 1.60: DRAWN BY DESIGNER
- SECTION 1.61: CHECKED BY DESIGNER
- SECTION 1.62: APPROVED BY DESIGNER
- SECTION 1.63: TITLE DESIGNER
- SECTION 1.64: PROJECT NO. DESIGNER
- SECTION 1.65: SHEET NO. DESIGNER
- SECTION 1.66: TOTAL SHEETS DESIGNER
- SECTION 1.67: CLIENT DESIGNER
- SECTION 1.68: ARCHITECT DESIGNER
- SECTION 1.69: ENGINEER DESIGNER
- SECTION 1.70: LANDSCAPE ARCHITECT DESIGNER
- SECTION 1.71: PLUMBER DESIGNER
- SECTION 1.72: ELECTRICIAN DESIGNER
- SECTION 1.73: MECHANICAL ENGINEER DESIGNER
- SECTION 1.74: FURNITURE DESIGNER DESIGNER
- SECTION 1.75: SIGNAGE DESIGNER DESIGNER
- SECTION 1.76: ACCESSORY DESIGNER DESIGNER
- SECTION 1.77: SCHEDULE DESIGNER DESIGNER
- SECTION 1.78: SPECIFICATIONS DESIGNER DESIGNER
- SECTION 1.79: NOTES DESIGNER DESIGNER
- SECTION 1.80: REVISIONS DESIGNER DESIGNER
- SECTION 1.81: INDEX DESIGNER DESIGNER
- SECTION 1.82: APPENDICES DESIGNER DESIGNER
- SECTION 1.83: GLOSSARY DESIGNER DESIGNER
- SECTION 1.84: BIBLIOGRAPHY DESIGNER DESIGNER
- SECTION 1.85: REFERENCES DESIGNER DESIGNER
- SECTION 1.86: CONTACTS DESIGNER DESIGNER
- SECTION 1.87: OTHER INFORMATION DESIGNER DESIGNER
- SECTION 1.88: LEGEND DESIGNER DESIGNER
- SECTION 1.89: SCALE DESIGNER DESIGNER
- SECTION 1.90: DATE DESIGNER DESIGNER
- SECTION 1.91: DRAWN BY DESIGNER DESIGNER
- SECTION 1.92: CHECKED BY DESIGNER DESIGNER
- SECTION 1.93: APPROVED BY DESIGNER DESIGNER
- SECTION 1.94: TITLE DESIGNER DESIGNER
- SECTION 1.95: PROJECT NO. DESIGNER DESIGNER
- SECTION 1.96: SHEET NO. DESIGNER DESIGNER
- SECTION 1.97: TOTAL SHEETS DESIGNER DESIGNER
- SECTION 1.98: CLIENT DESIGNER DESIGNER
- SECTION 1.99: ARCHITECT DESIGNER DESIGNER
- SECTION 2.00: ENGINEER DESIGNER DESIGNER

JOB START DESCRIPTION
 PART 1: DATE
 PART 2: DATE
 PART 3: DATE
 PART 100: DATE


DATE: 3/15/18
 PROJECT NO.: 2018-13
 SHEET NUMBER:
A0.0

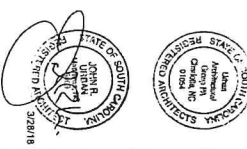

COVER SHEET
 BAREFOOT DYE
 TOWNHOMES
 7-UNIT BUILDING

D.R. HORTON
 America's Builder
 DHI
 NYS
 SE

URBAN
 ARCHITECTURAL GROUP
 201 N. 10TH ST.
 SUITE 200
 WASHINGTON, DC 20004
 202.462.1111
 WWW.URBANARCHITECTS.COM

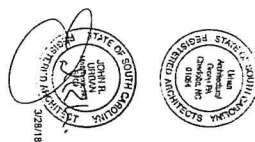

JOB START DESCRIPTION	
JOB #	DATE:
DRAWN BY:	LOT #:
SUBDIVISION:	
BUYER:	

A1.2

EXTERIOR REAR
ELEVATION

**BAREFOOT DYE
TOWNHOMES
7-UNIT BUILDING**

D·R·HORTON **DHI**
NYSE
America's Builder

Copyright 2010, All Rights Reserved

ARCHITECTURAL GROUP
841.1879 W
704 R.L. 2429 W
1142 Mason Drive Suite 100
Midwest, Fort Collins CO 781
www.lisaadella.com

URBAN

A1.3