




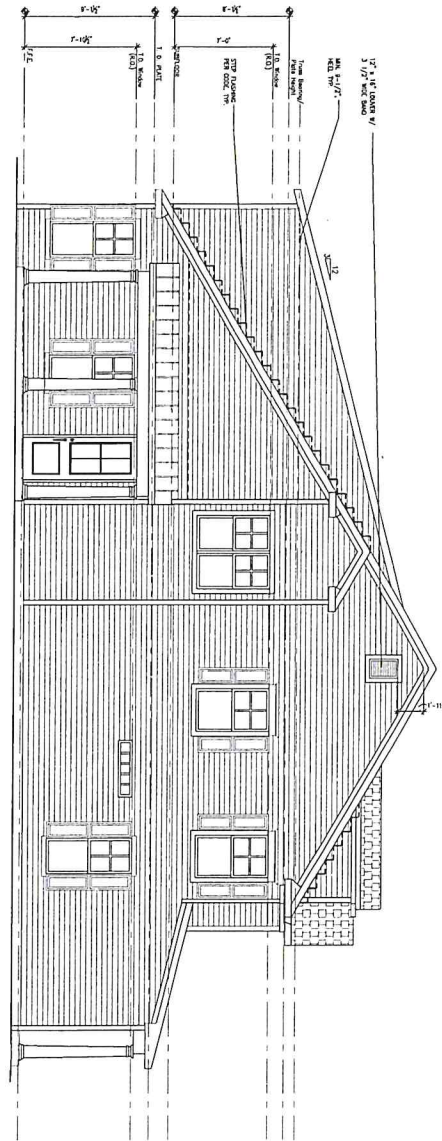

SIDE ELEVATION
SCALE: 1/4" = 1'-0"

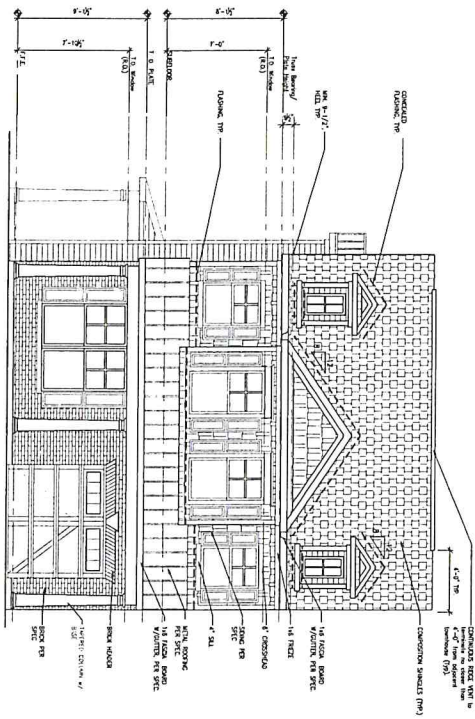


FRONT ELEVATION "C"
SCALE: 1/4" = 1'-0"

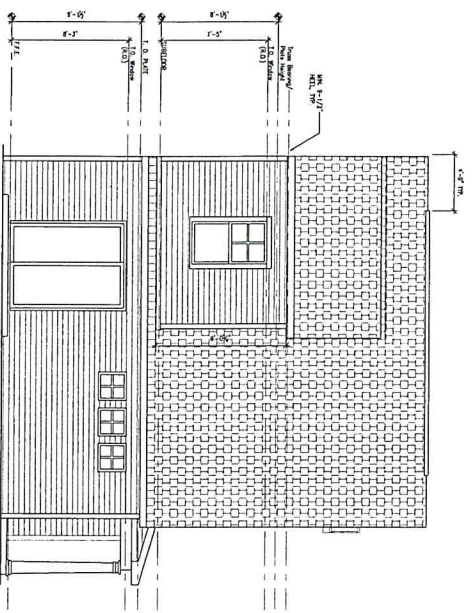

REAR ELEVATION
SCALE: 1/4" = 1'-0"

DATE	1/24/11
PROJECT NO.	2010-91
SHEET NUMBER	1.1
DATE	
DESIGNER	
CHECKER	
DATE	
PROJECT DESCRIPTION	
OWNER	

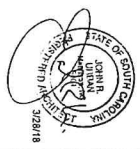


URBAN


ARCHITECTURAL GROUP

704.519.9191
1121 BAYVIEW - SUITE 200
DALLAS, TEXAS 75210


D.R. HORTON **DRI NYSE**
America's Builder

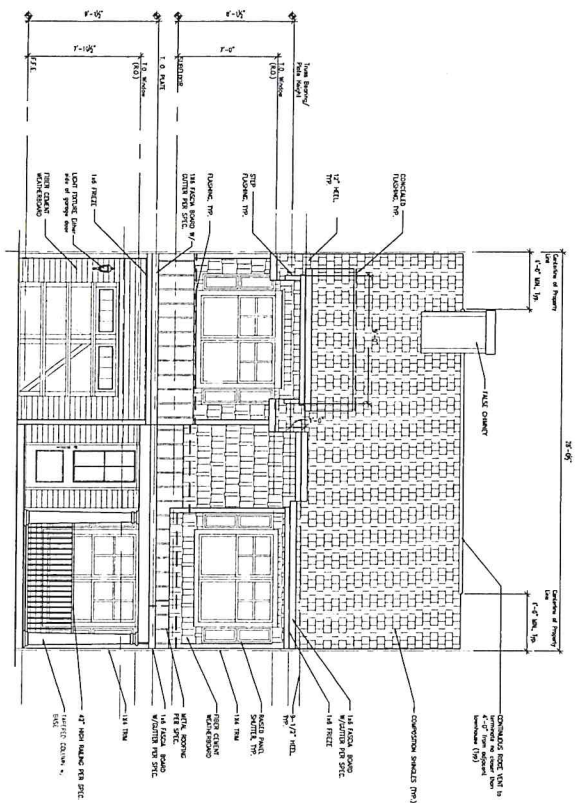

FRONT ELEVATION "C"

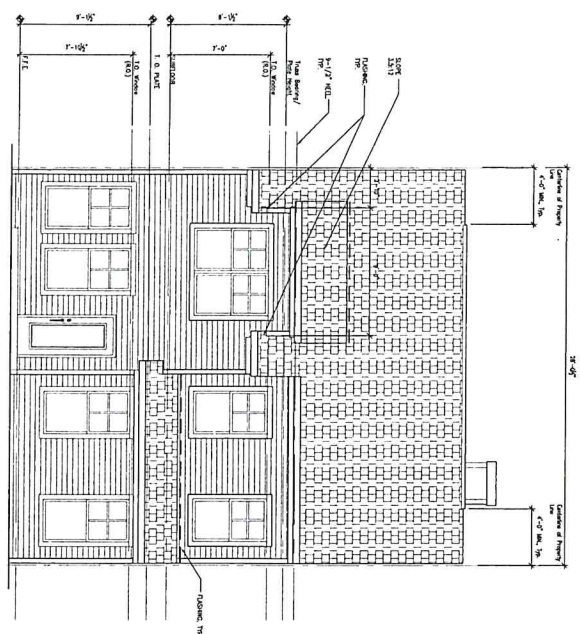

REAR ELEVATION

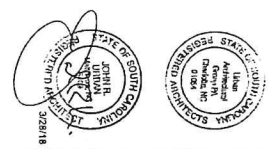

JOB START DESCRIPTION	
DATE	3/28/18
PROJECT NO.	2018-31
DESIGNER	JOH F.
REVISION	
DATE	

DATE: 3/28/18	
PROJECT NO: 2018-31	
SHEET NUMBER:	
1.1	


LINDERBACH

EXTERIOR ELEVATIONS

DATE	REVISION #	UPDATED BY

ARCHITECTURAL GROUP

704 S. LINDEN ST.
 SUITE 200
 GREENSBORO, NC 27401
 TEL: 336.733.1111
 WWW.URBANARCHITECTS.COM

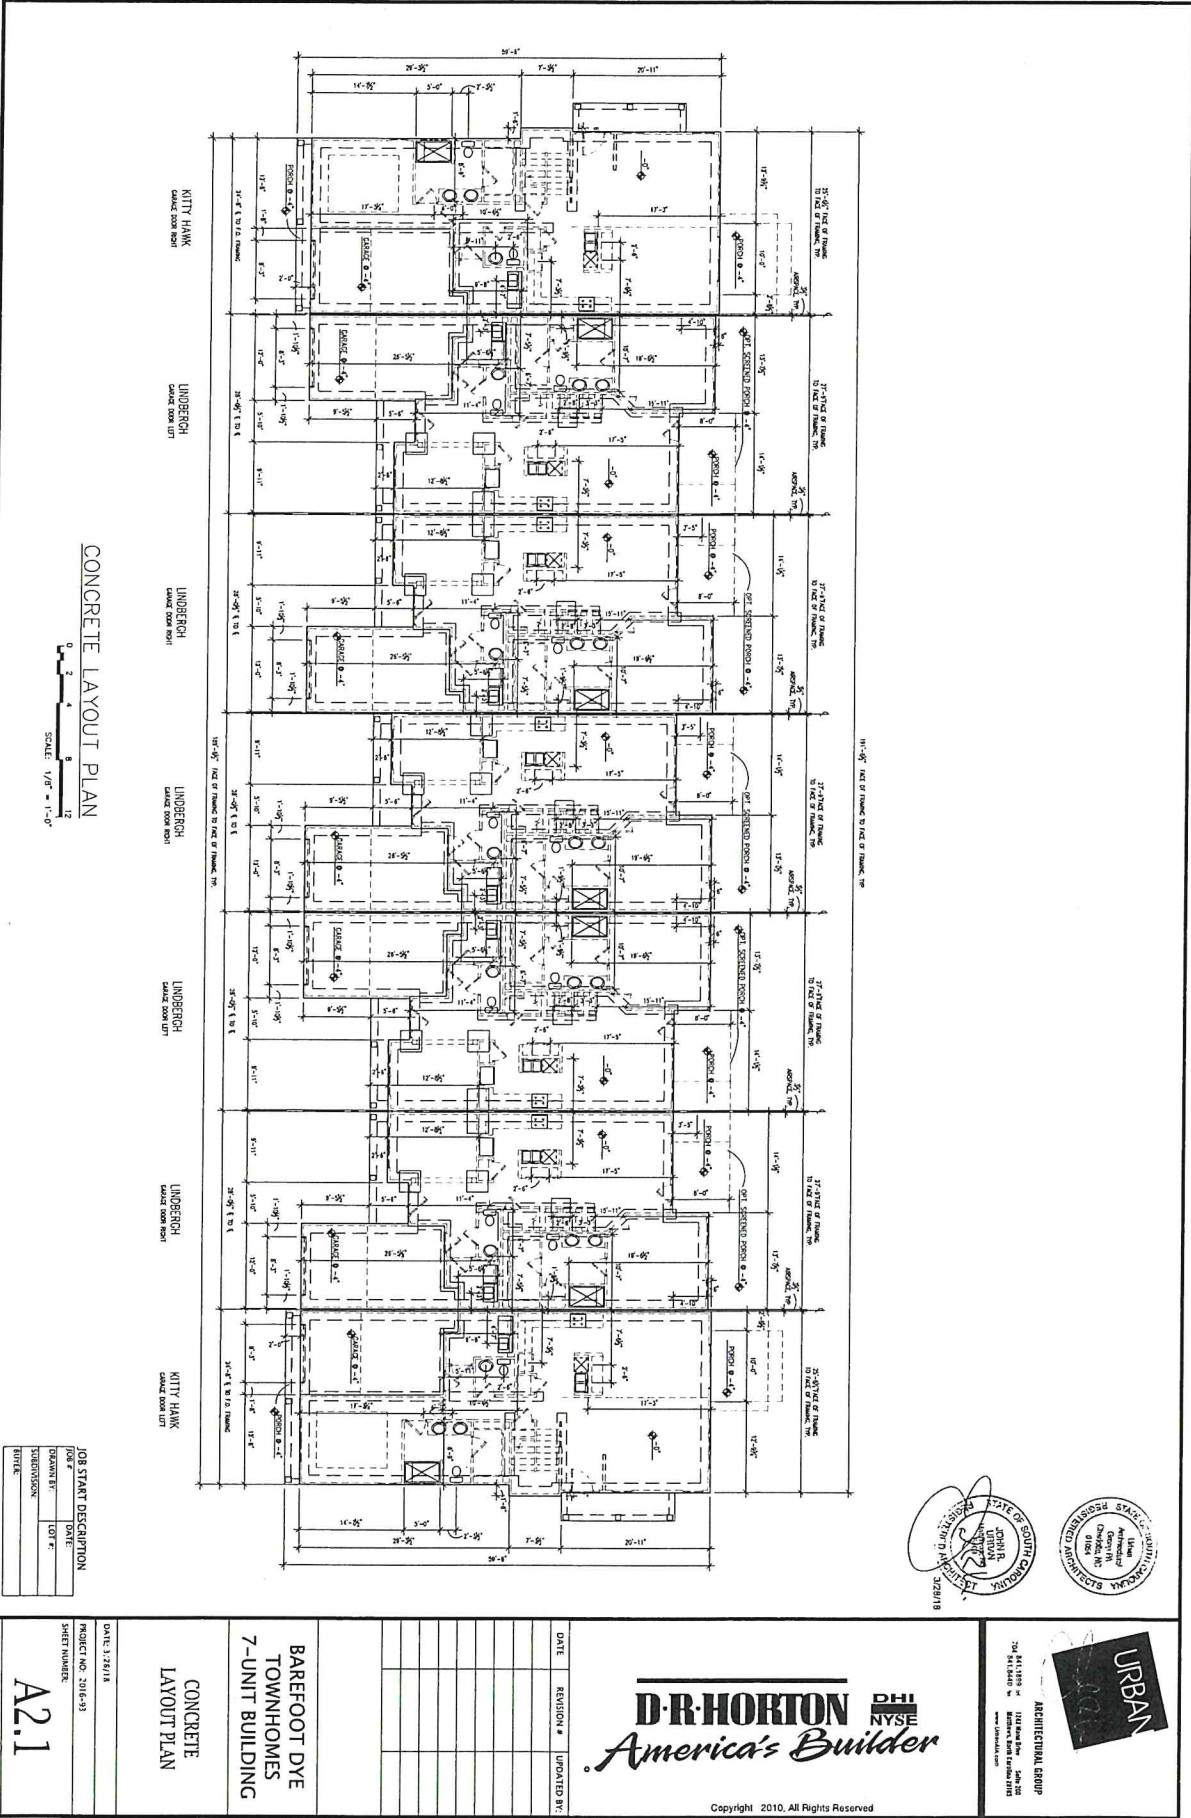

CONCRETE LAYOUT PLAN

SCALE: 1/8" = 1'-0"

JOB START DESCRIPTION	
DATE	BY
DESIGNED BY	DATE
CHECKED BY	DATE
DATE	BY

DATE: 1/28/18
PROJECT NO: 2016-93
SHEET NUMBER
A2.1


CONCRETE
LAYOUT PLAN

BARFOOT DYE
TOWNHOMES
7-UNIT BUILDING

DATE	REVISION #	UPDATED BY:



Copyright 2010, All Rights Reserved


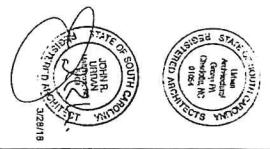


URBAN

ARCHITECTURAL GROUP

201 S. 10th St.
Suite 200
Columbia, SC 29201
704.544.4444
www.urbanarchitectural.com

M. BATH OPTION
SCALE 1/4" = 1'-0"

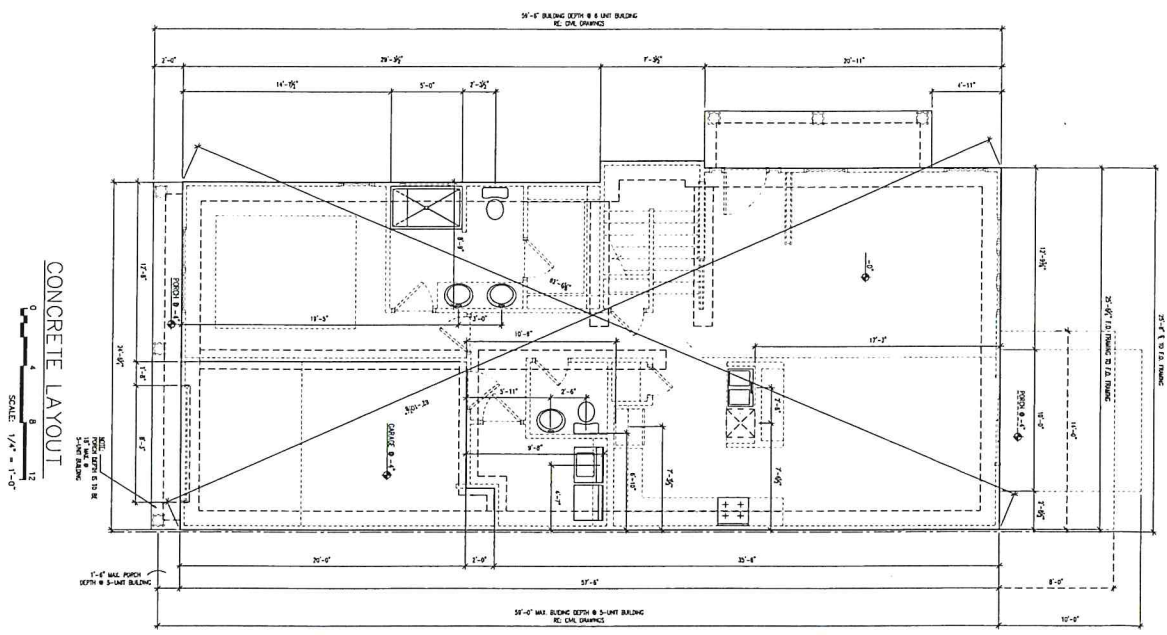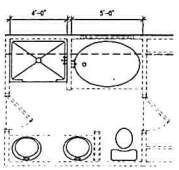

CONCRETE LAYOUT
SCALE 1/4" = 1'-0"

JOB START DESCRIPTION	
DATE	1/21/18
PROJECT NO.	2018-91
SHEET NUMBER	2.1
DATE	

KITTY HAWK

CONCRETE LAYOUT PLAN

D.R. HORTON
America's Builder

Copyright 2010, All Rights Reserved




NYSE

URBAN

ARCHITECTURAL GROUP

704 S. 11th St. Suite 100
Fort Worth, TX 76102
Phone: 817.331.1111
www.urbanarchitect.com

STATE OF TEXAS
COUNTY OF TARRANT
JAN 21 2018

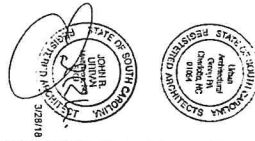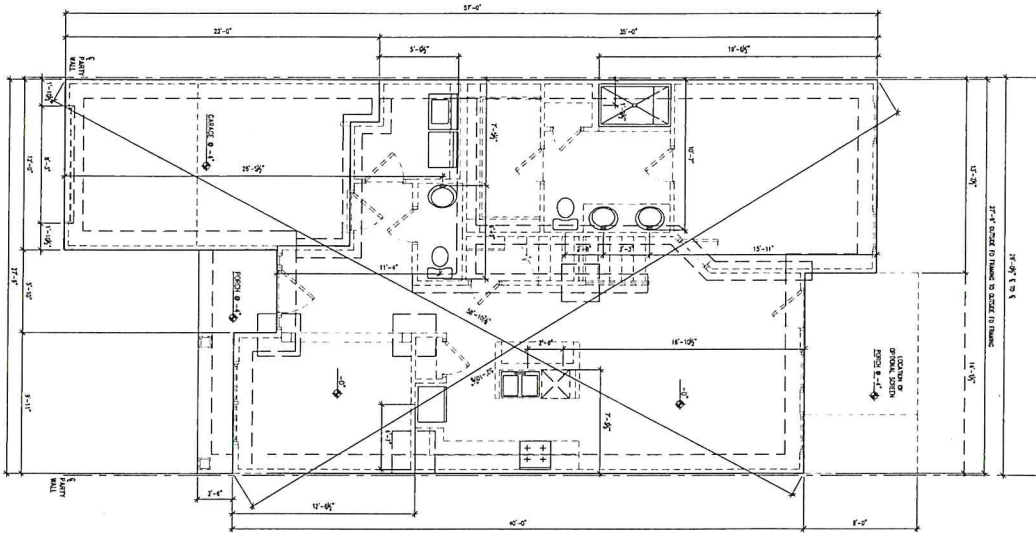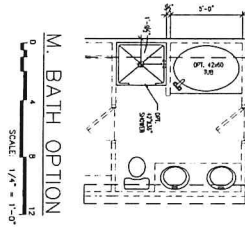

JOB START DESCRIPTION	
DATE	DATE
DRAWN BY	LOU F.
SUBMISSION	
BY DATE	

URBAN ARCHITECTURAL GROUP
704 341 3400
www.urbandesign.com

D.R. HORTON America's Builder


DHI NYSE

DATE: 3/28/18

PROJECT NO: 2016-13

SHEET NUMBER: 2.1

DATE	REVISION #	UPDATED BY

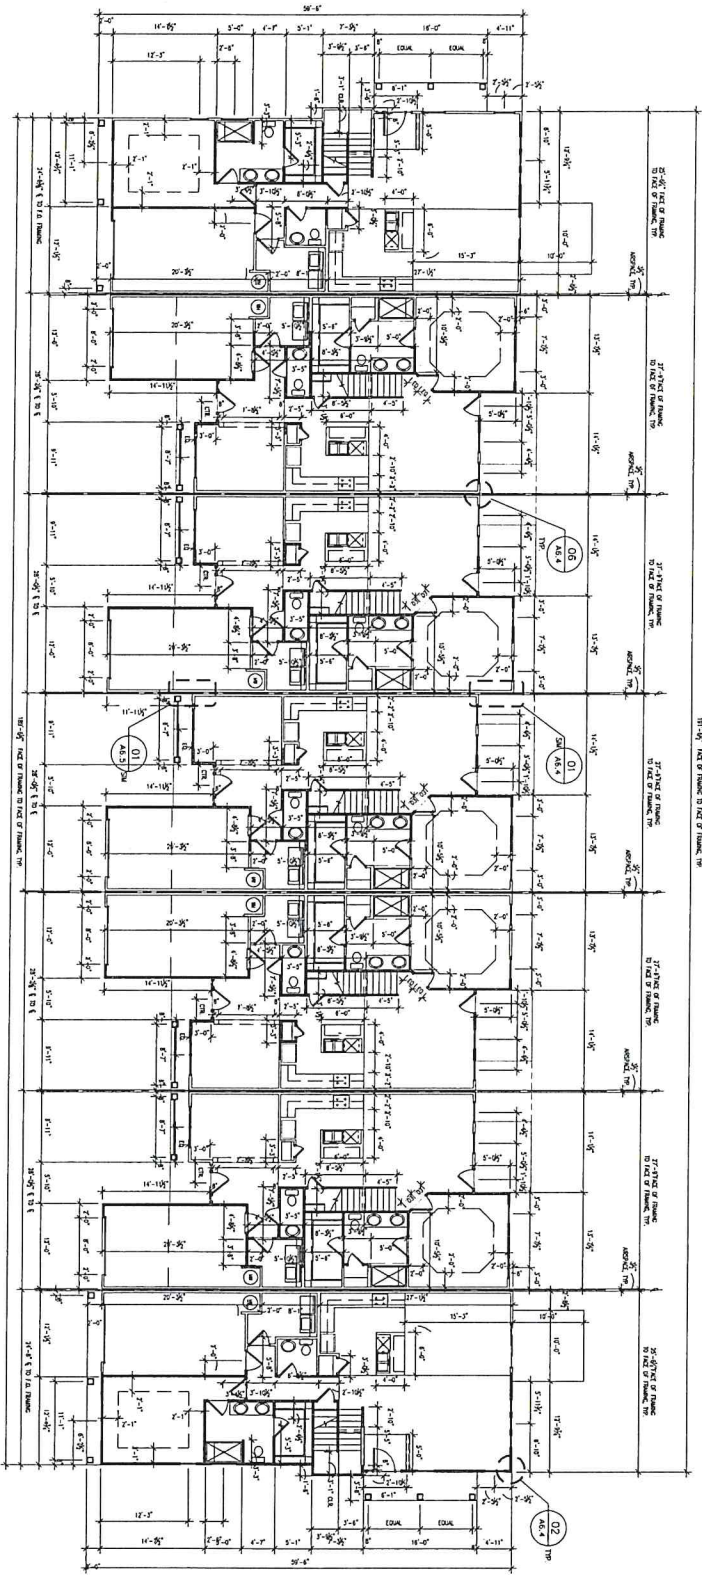

FIRST FLOOR PLAN

SCALE: 1/8" = 1'-0"

JOB START DESCRIPTION	DATE
PROJECT NO. 2016-03	DATE
DESIGNER	DATE
CONTRACTOR	DATE
OWNER	DATE

DATE 1/24/18
PROJECT NO. 2016-03
SHEET NUMBER
A3.1

FIRST FLOOR PLAN


BAREFOOT DYE
TOWNHOMES
7-UNIT BUILDING

DATE	REVISION #	UPDATED BY

D.R. HORTON PHI
America's Builder

Copyright 2010, All Rights Reserved

URBAN
ARCHITECTURAL GROUP
201 S. 1st St.
1120 Main Ave.
Tulsa, OK 74103
www.urbanarchitect.com

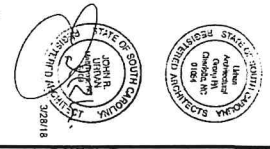



KITTY HAWK
CAVING DOOR LOT

SCALE: 1/8" = 1'-0"

A3.2

**BAREFOOT DYE
TOWNHOMES
7-UNIT BUILDING**


D·R·HORTON **DHI**
NYSE
America's Builder

Copyright 2010, All Rights Reserved




ARCHITECTURAL GROUP
841.1893 M
841.8443 W
1243 Main Drive Suite 200
Midtown, North Carolina 27118
www.azarchitect.com

URBAN

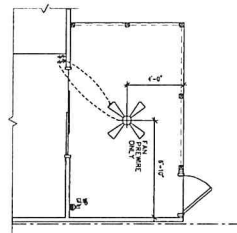


SCREENED PORCH ELECTRICAL PLAN

SCALE 1/4" = 1'-0"

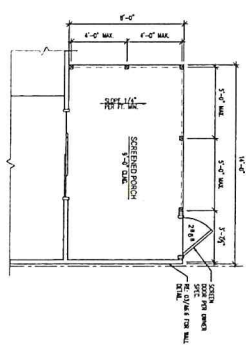


SCREENED PORCH FLOOR PLAN

SCALE 1/4" = 1'-0"

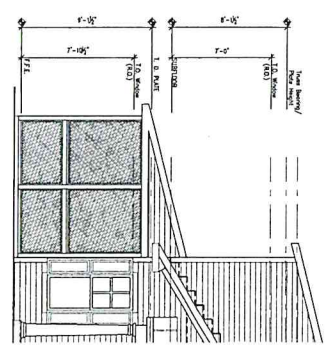

SIDE ELEVATION

SCALE 1/4" = 1'-0"

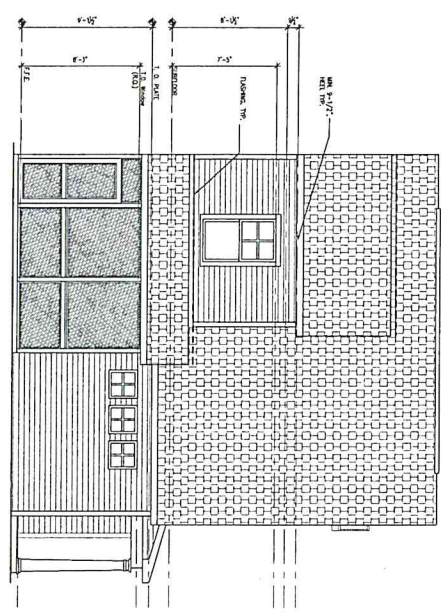

REAR ELEVATION

SCALE 1/4" = 1'-0"

JOB START DESCRIPTION	
DATE	
DESIGNER	
REVISIONS	
DATE	

DATE: 3/28/18	
PROJECT NO: 2018-31	
SHEET NUMBER:	
3.2	

SCREENED PORCH
OPTIONS


KITTY HAWK

DATE	REVISION #	UPDATED BY

D.R. HORTON **DHI NYSE**
America's Builder


Copyright 2010, All Rights Reserved

ARCHITECTURAL GROUP
1000 14th Street, NW
Atlanta, GA 30334
404.525.1100
www.urbandesign.com

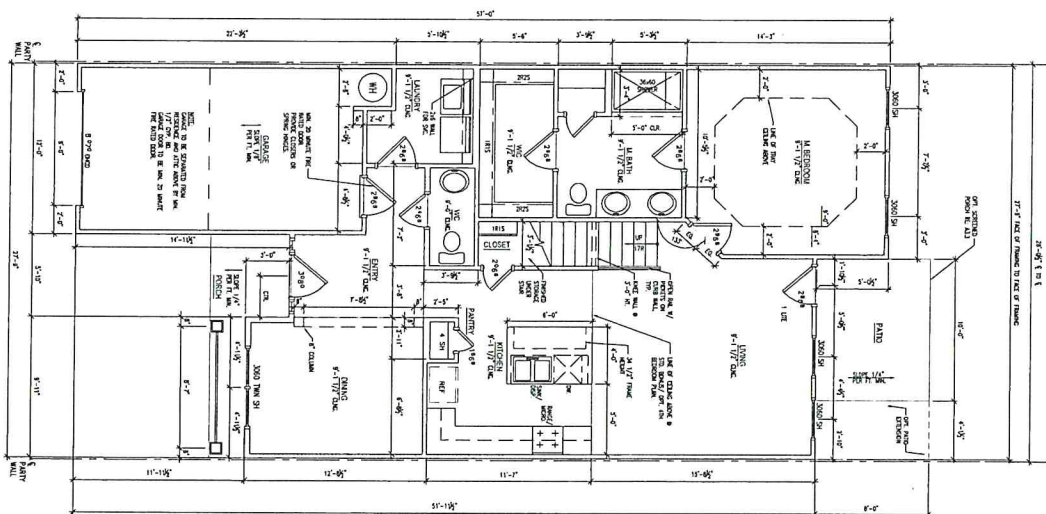

GENERAL NOTES AND LEGEND


1. PLATE HEIGHTS ARE AT 9'-1 1/2" @ 1ST FLOOR AND @ 8'-1 1/2" @ 2ND FLOOR.
2. ALL DOORS TO BE CENTERED IN OPENING, OR OFFSET FROM CORNER 4".

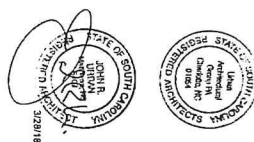

JOB START DESCRIPTION	
FOR #	DATE
DRAWN BY:	LOT #:
SUBMISSIONS:	
BUYER:	


[illegible]

Copyright 2010, All Rights Reserved

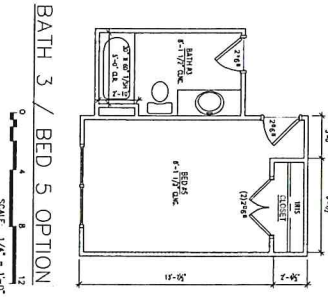


GENERAL NOTES AND LEGEND

1. FLOOR HEIGHTS ARE AT 9'-1 1/2" • 1ST FLOOR AND • 8'-1 1/2" • 2ND FLOOR.
2. ALL DOORS TO BE CENTRED IN OPENING, OR OFFSET FROM CORNER 4"

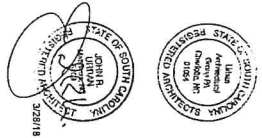


JOB START DESCRIPTION	
JOB #	DATE
DRAWN BY	LOT #
SUBDIVISION	
BUYER	

 [illegible]



JOB START DESCRIPTION	
JOB #	DATE
DRAWN BY:	LOT #:
SUBDIVISION:	
BUYER:	

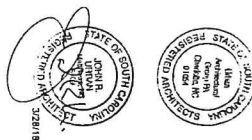

ARCHITECTURAL GROUP
341.1899 W
841.8440 W
1142 Mason Drive Suite 200
Mannheim, North Carolina 27518
www.ubmarch.com



D·R·HORTON **DHI**
NYSE
America's Builder

Copyright 2010, All Rights Reserved

**BAREFOOT DYE
TOWNHOMES
7-UNIT BUILDING**

ROOF PLAN

DATE: 3/26/18

SHEET NUMBER:

A4.1