

[illegible]

PROJECT NO: 2016-93
SHEET NUMBER:
4.1

4.1

ROOF PLAN

KITTY HAWK

DATE	REVISION #	UPDATED BY:
------	------------	-------------

REVISION #	DATE

UPDATED BY:	
-------------	--

D·R·HORTON **DHI**
NYSE
America's Builder

Copyright 2010. All Rights Reserved

ARCHITECTURAL GROUP
Bdl. 1829 W
704 Bdl. 1840 W
1247 Ross Drive Suite 700
Northbrook, North Carolina 28162

URBAN

3/28/88



**LANDRICH
FURNITURE**

WEA. HOS. 2-PC.
EDWARD & CO. WEA.
WEE. HOS. 2-PC.
SOUTH WOOD. BEDDING
1-PC. HOS. 2-PC.
HOS. OF WEA. 2-PC.
HOS. OF WEA. 2-PC.

1178 SQ. FT. / 300' x 318' SQ. FT.
218' x 164' x 530' SQ. M.
241 SQ. M. BEDDING
24 SQ. FT. x 18' 8" / 240' SQ. M.
20' L. x 18' 8" / 20' L. x 180' SQ. M.
20' L. x 18' 8" / 20' L. x 180' SQ. M.
20' L. x 18' 8" / 20' L. x 180' SQ. M.



D·R·HORTON **DHI**
NYSE
America's Builder

Copyright 2010. All Rights Reserved.

JOB START DESCRIPTION	
JOB #	DATE
DRAWN BY:	LOT #
SUBDIVISION:	
BUYER:	

[illegible]

UNLESS OTHERWISE NOTED, ALL SWITCHES AND RECEPTS ARE TO BE LOCATED AT THE FOLLOWING HEIGHTS ABOVE FINISH FLOOR TO THE BOTTOM OF BOX AND RECEPT:

SWITCHES: 4'-0"

RECEPTS: 1'-6"


DATA OUTLETS: 1'-6"

TELEPHONE OUTLETS: 4'-0"

TELEVISION OUTLETS: 4'-0"

VIDEO OUTLETS: 4'-0"

- ELECTRICAL PLAN**
- 1. SWITCH, SINGLE POLE
 - 2. SWITCH, 3-WAY
 - 3. SWITCH, 4-WAY
 - 4. RECEPT, STANDARD OUTLET
 - 5. RECEPT, ON GFI CIRCUIT
 - 6. RECEPT, ON GFI CIRCUIT & 47
 - 7. RECEPT
 - 8. RECEPT, MAINT. ROOM, ON GFI CIRCUIT
 - 9. RECEPT, MAINT. ROOM
 - 10. RECEPT, 20V (1/2 SWITCH)
 - 11. RECEPT, 100V MAINT.
 - 12. LIGHT OUTLET, WALL MOUNTED
 - 13. LIGHT OUTLET, CEILING MOUNTED
 - 14. LIGHT OUTLET, RECESS. ROOF
 - 15. RECESS. ROOF LIGHT OUTLET, RECESS. ROOF
 - 16. EXHAUST FAN, LIGHT OUTLET
 - 17. EXHAUST FAN
 - 18. 100V LIGHT
 - 19. DATA OUTLET
 - 20. CABLE OUTLET
 - 21. TELEPHONE OUTLET
 - 22. SMOKE DETECTOR
 - 23. THERMOSTAT
 - 24. ELECTRIC PANEL
 - 25. DISCONNECT SWITCH
 - 26. FLUORESCENT LIGHT FIXTURE - CLAMP
 - 27. CLAMP FAN
 - 28. CLAMP FAN PROJECT

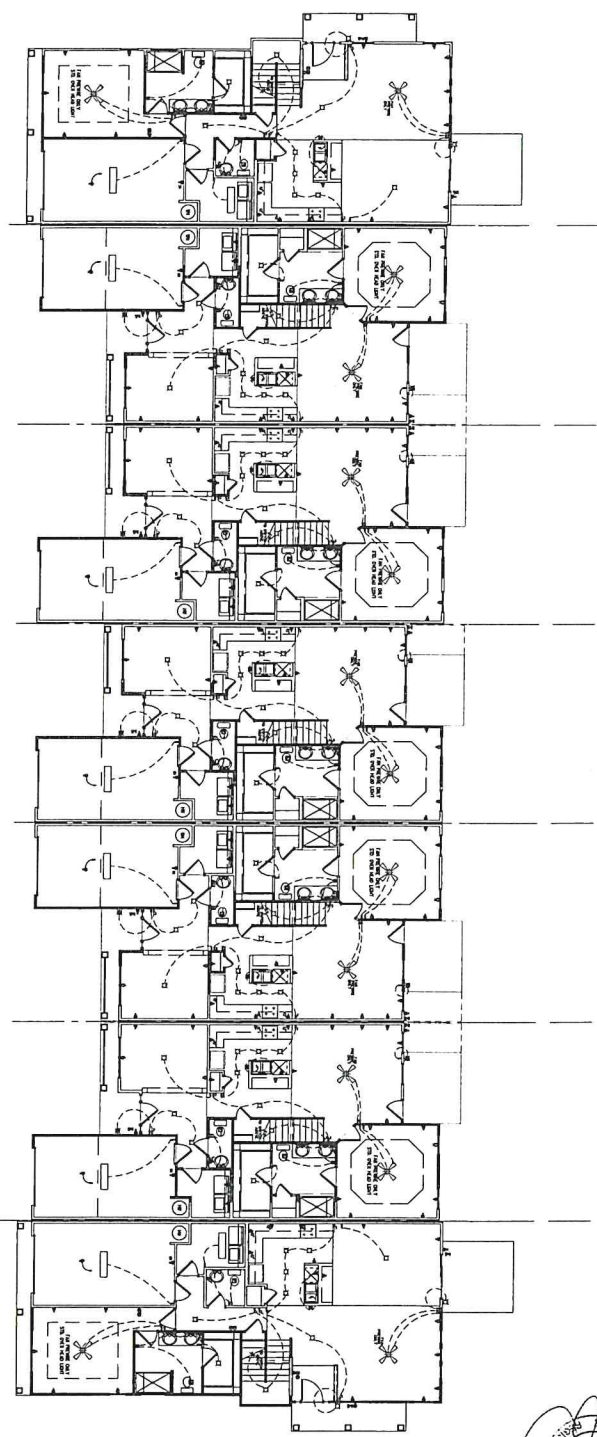

FIRST FLOOR PLAN

SCALE: 1/8" = 1'-0"

JOB START DESCRIPTION

DATE	2/28/18
PROJECT NO.	2016-43
SHEET NUMBER	101
DATE	2/28/18
PROJECT NO.	2016-43
SHEET NUMBER	101
DATE	2/28/18



D.R. HORTON
America's Builder

DATE: 2/28/18

REVISION #

UPDATED BY

URBAN

ARCHITECTURAL GROUP

4411 18th St. Suite 200
New York, NY 10011

BAREFOOT DYE TOWNHOMES 7-UNIT BUILDING

FIRST FLOOR ELECTRICAL


A5.1

JOB START DESCRIPTION	
JOB #	DATE
DRAWN BY:	LOT #:
SUBDIVISION:	
BUYER:	

OUTLETS.....+1°
 TILTING.....+1°
 TILTING.....+1°
 OUTLETS (CARGO).....+18°
 WIDEN OUTLETS.....+48°


5 SWITCH, SINGLE POL.

- [illegible]

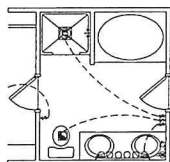

M. BATH OPTION

SCALE: 1/4" = 1'-0"

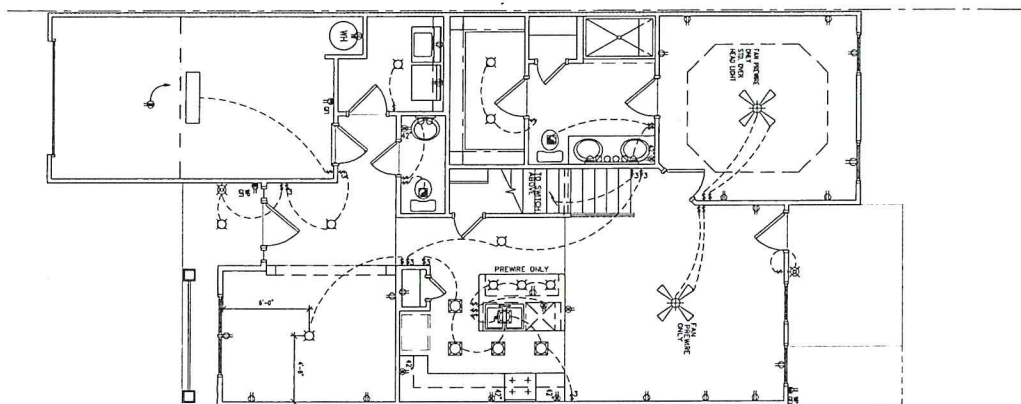

FIRST FLOOR PLAN

SCALE: 1/4" = 1'-0"

JOB START DESCRIPTION	
JOB #	DATE:
DRAWN BY:	LOT #:
SUBDIVISION:	
BUYER:	

[illegible]

Copyright 2010, All Rights Reserved



UNLESS OTHERWISE NOTED, INSTALL SWITCHES AND RECEPTACLES AT THE FOLLOWING HEIGHTS ABOVE FINISH FLOOR TO THE BOTTOM OF BOX AND RECEPTACLE:

SWITCHES _____ 4'-0"
 OUTLETS (SINGLE) _____ 1'-6"
 OUTLETS (DOUBLE) _____ 2'-0"
 RECEPTACLES _____ 1'-6"

ELECTRICAL PLAN SYMBOLS

- 1. SINGLE SWITCH, FAN
- 2. SINGLE SWITCH, 3-WAY
- 3. SINGLE SWITCH, 4-WAY
- 4. RECEPTACLE, STANDARD OUTLET
- 5. RECEPTACLE, 20V
- 6. RECEPTACLE, 1/2 SWITCH
- 7. RECEPTACLE, 1/4 SWITCH
- 8. RECEPTACLE, 1/8 SWITCH
- 9. RECEPTACLE, 1/4 SWITCH
- 10. RECEPTACLE, 1/8 SWITCH
- 11. RECEPTACLE, 1/4 SWITCH
- 12. RECEPTACLE, 1/8 SWITCH
- 13. RECEPTACLE, 1/4 SWITCH
- 14. RECEPTACLE, 1/8 SWITCH
- 15. RECEPTACLE, 1/4 SWITCH
- 16. RECEPTACLE, 1/8 SWITCH
- 17. RECEPTACLE, 1/4 SWITCH
- 18. RECEPTACLE, 1/8 SWITCH
- 19. RECEPTACLE, 1/4 SWITCH
- 20. RECEPTACLE, 1/8 SWITCH
- 21. RECEPTACLE, 1/4 SWITCH
- 22. RECEPTACLE, 1/8 SWITCH
- 23. RECEPTACLE, 1/4 SWITCH
- 24. RECEPTACLE, 1/8 SWITCH
- 25. RECEPTACLE, 1/4 SWITCH
- 26. RECEPTACLE, 1/8 SWITCH
- 27. RECEPTACLE, 1/4 SWITCH
- 28. RECEPTACLE, 1/8 SWITCH
- 29. RECEPTACLE, 1/4 SWITCH
- 30. RECEPTACLE, 1/8 SWITCH
- 31. RECEPTACLE, 1/4 SWITCH
- 32. RECEPTACLE, 1/8 SWITCH
- 33. RECEPTACLE, 1/4 SWITCH
- 34. RECEPTACLE, 1/8 SWITCH
- 35. RECEPTACLE, 1/4 SWITCH
- 36. RECEPTACLE, 1/8 SWITCH
- 37. RECEPTACLE, 1/4 SWITCH
- 38. RECEPTACLE, 1/8 SWITCH
- 39. RECEPTACLE, 1/4 SWITCH
- 40. RECEPTACLE, 1/8 SWITCH
- 41. RECEPTACLE, 1/4 SWITCH
- 42. RECEPTACLE, 1/8 SWITCH
- 43. RECEPTACLE, 1/4 SWITCH
- 44. RECEPTACLE, 1/8 SWITCH
- 45. RECEPTACLE, 1/4 SWITCH
- 46. RECEPTACLE, 1/8 SWITCH
- 47. RECEPTACLE, 1/4 SWITCH
- 48. RECEPTACLE, 1/8 SWITCH
- 49. RECEPTACLE, 1/4 SWITCH
- 50. RECEPTACLE, 1/8 SWITCH
- 51. RECEPTACLE, 1/4 SWITCH
- 52. RECEPTACLE, 1/8 SWITCH
- 53. RECEPTACLE, 1/4 SWITCH
- 54. RECEPTACLE, 1/8 SWITCH
- 55. RECEPTACLE, 1/4 SWITCH
- 56. RECEPTACLE, 1/8 SWITCH
- 57. RECEPTACLE, 1/4 SWITCH
- 58. RECEPTACLE, 1/8 SWITCH
- 59. RECEPTACLE, 1/4 SWITCH
- 60. RECEPTACLE, 1/8 SWITCH
- 61. RECEPTACLE, 1/4 SWITCH
- 62. RECEPTACLE, 1/8 SWITCH
- 63. RECEPTACLE, 1/4 SWITCH
- 64. RECEPTACLE, 1/8 SWITCH
- 65. RECEPTACLE, 1/4 SWITCH
- 66. RECEPTACLE, 1/8 SWITCH
- 67. RECEPTACLE, 1/4 SWITCH
- 68. RECEPTACLE, 1/8 SWITCH
- 69. RECEPTACLE, 1/4 SWITCH
- 70. RECEPTACLE, 1/8 SWITCH
- 71. RECEPTACLE, 1/4 SWITCH
- 72. RECEPTACLE, 1/8 SWITCH
- 73. RECEPTACLE, 1/4 SWITCH
- 74. RECEPTACLE, 1/8 SWITCH
- 75. RECEPTACLE, 1/4 SWITCH
- 76. RECEPTACLE, 1/8 SWITCH
- 77. RECEPTACLE, 1/4 SWITCH
- 78. RECEPTACLE, 1/8 SWITCH
- 79. RECEPTACLE, 1/4 SWITCH
- 80. RECEPTACLE, 1/8 SWITCH
- 81. RECEPTACLE, 1/4 SWITCH
- 82. RECEPTACLE, 1/8 SWITCH
- 83. RECEPTACLE, 1/4 SWITCH
- 84. RECEPTACLE, 1/8 SWITCH
- 85. RECEPTACLE, 1/4 SWITCH
- 86. RECEPTACLE, 1/8 SWITCH
- 87. RECEPTACLE, 1/4 SWITCH
- 88. RECEPTACLE, 1/8 SWITCH
- 89. RECEPTACLE, 1/4 SWITCH
- 90. RECEPTACLE, 1/8 SWITCH
- 91. RECEPTACLE, 1/4 SWITCH
- 92. RECEPTACLE, 1/8 SWITCH
- 93. RECEPTACLE, 1/4 SWITCH
- 94. RECEPTACLE, 1/8 SWITCH
- 95. RECEPTACLE, 1/4 SWITCH
- 96. RECEPTACLE, 1/8 SWITCH
- 97. RECEPTACLE, 1/4 SWITCH
- 98. RECEPTACLE, 1/8 SWITCH
- 99. RECEPTACLE, 1/4 SWITCH
- 100. RECEPTACLE, 1/8 SWITCH

MASTER SUITE OPTION

SCALE: 1/4" = 1'-0"


SECOND FLOOR PLAN - STANDARD

SCALE: 1/4" = 1'-0"

BATH 3 / BED 5 OPTION

SCALE: 1/4" = 1'-0"

JOB START DESCRIPTION	
DATE	10/1/11
DESIGNER	JOE P.
DATE	10/1/11
DATE	10/1/11
DATE	10/1/11

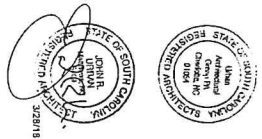

6.2

ELECTRICAL PLAN

LINDERBERG

DATE: 1/2/11

PROJECT NO.: 2011-51

SHEET NUMBER

D.R. HORTON PHI

America's Builder

Copyright 2010, All Rights Reserved

ARCHITECTURAL GROUP


101 Main Street, Suite 200

Wichita, KS 67202

Phone: 316.261.1111


Fax: 316.261.1112

www.drhorton.com

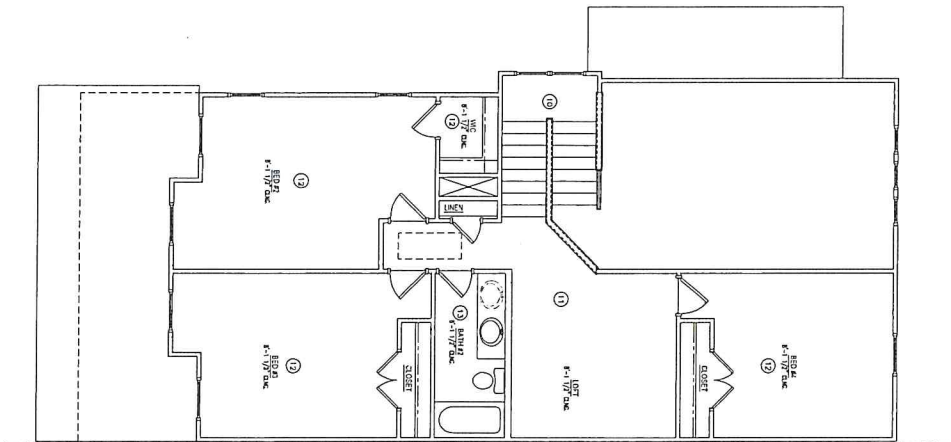


SECOND FLOOR PLAN

SCALE 1/4" = 1'-0"

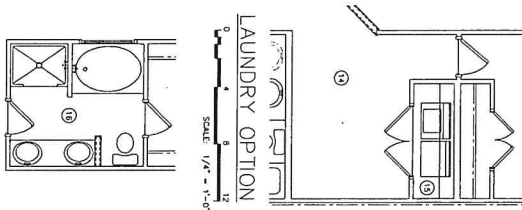

LAUNDRY OPTION

M. BATH OPTION

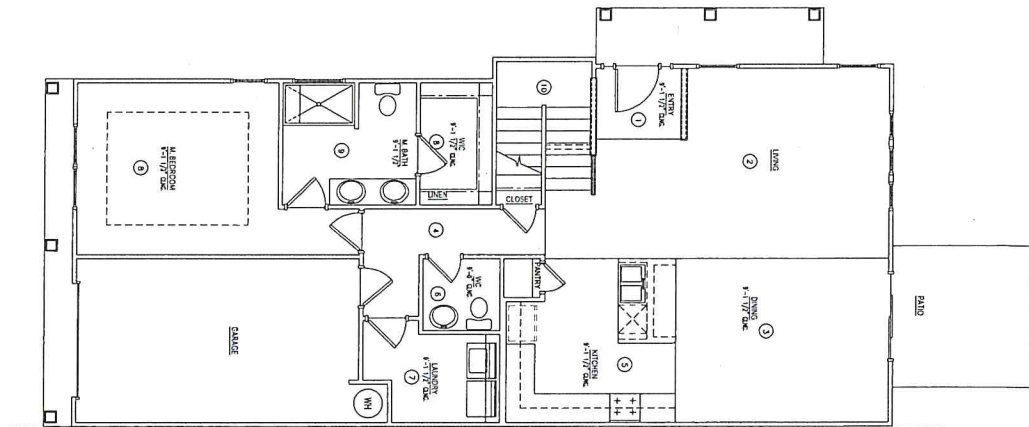

FIRST FLOOR PLAN

SCALE 1/4" = 1'-0"

JOB START DESCRIPTION	
DATE	10/17
DESIGNER	10/17
CHECKER	10/17
DATE	10/17

7.1

FIRST FLOOR
COVERING

KITTY HAWK



DATE	REVISION #	UPDATED BY

D.R. HORTON
America's Builder


Copyright 2010. All Rights Reserved

ARCHITECTURAL GROUP
1112 Main Ave., Suite 200
New York, NY 10013
Tel: 212.312.1112
Fax: 212.312.1113
www.drhorton.com



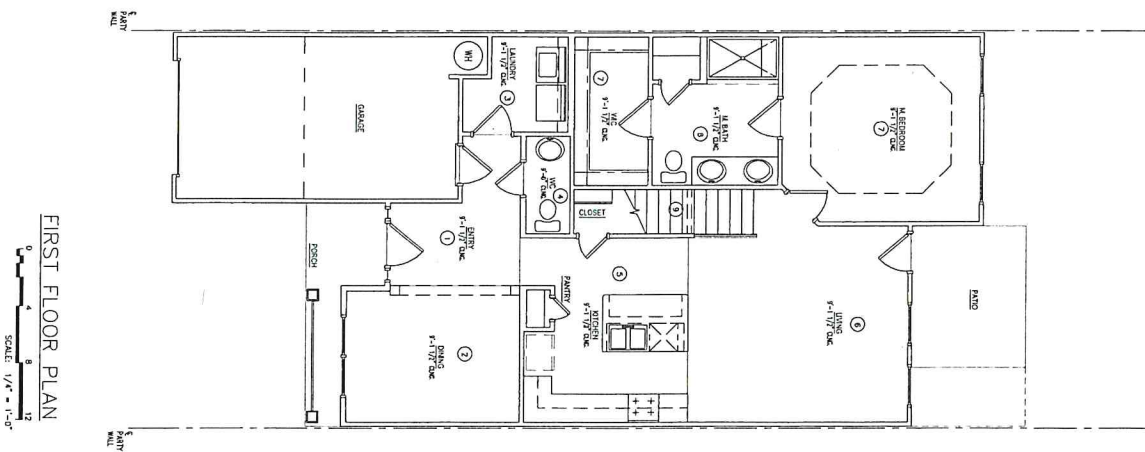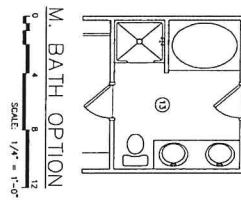

JOB START DESCRIPTION	
DATE	DATE
DRAWN BY	LOI F
SUBMISSION	
DATE	

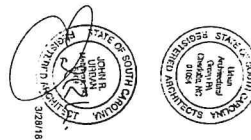


URBAN ARCHITECTURAL GROUP 704 S. 1st St. Suite 200 Columbia, SC 29201 803.799.1111 www.urbanarchitect.com		D.R. HORTON America's Builder DHI NYSE		Copyright 2010. All Rights Reserved	
DATE: 1/23/18 PRODUCT NO.: 2018-93 SHEET NUMBER: 7.1		LINDERBACH FIRST FLOOR COVERING		DATE: 1/23/18 REVISION # UPDATED BY:	



SECOND FLOOR PLAN - MASTER SUITE OPTION



 SECOND FLOOR PLAN - STANDARD



BATH 3 / BED 5 OPTION

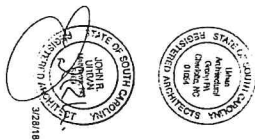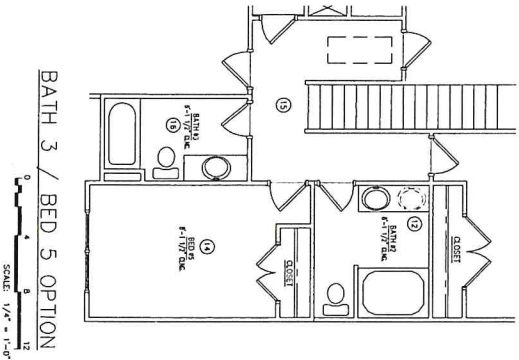

JOB START DESCRIPTION	
DATE	
DESIGNER	
DATE	
REVISION	

DATE: 1/24/18
PROJECT NO: 2018-91
SHEET NUMBER: 7.2

LINDERBACH

SECOND FLOOR COVERING

DATE

REVISION #

UPDATED BY:

D.R. HORTON

PHI NYSE


America's Builder

URBAN


ARCHITECTURAL GROUP

704 S. 1ST ST. #100
PHILADELPHIA, PA 19106
TEL: 215.575.1000
WWW.URBANARCHITECTS.COM


SHUTTERS
= BLACK

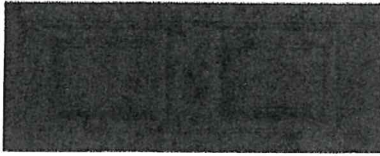


EXTERIOR DOOR
=Holy City Red
DCR038

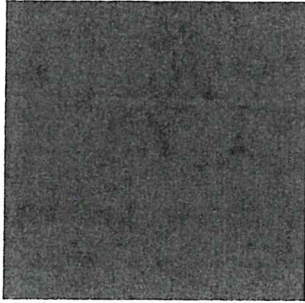


FIBER CEMENT
AND PRIVACY
PANEL FENCE
COLORS = ANTIQUE
PEWTER DCR057
WINDOW, CORNER,
TRIM=WHITE

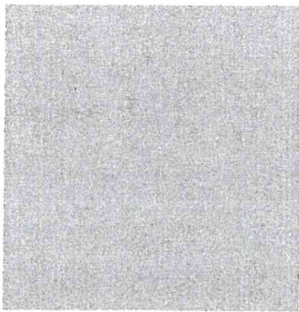

6' x6' PRIVACY PANEL
SIMTEK IN ASHLAND
STYLE AND COLOR=
NANTUCKET GRAY

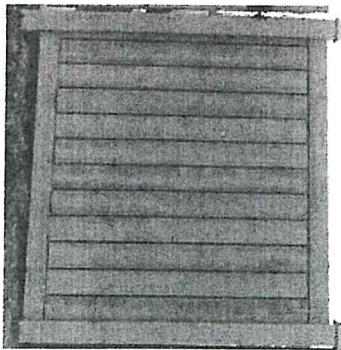


BRICK IS CAPERS
ISLAND QUEEN SIZE
BY MERIDIAN BRICK

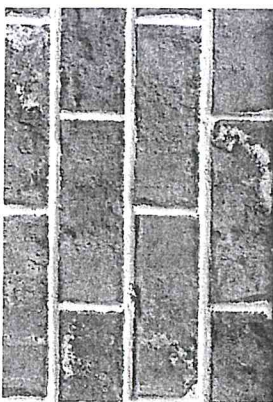


ACCENT ROOF on Front-STANDING SEAM

Color=Matte Black

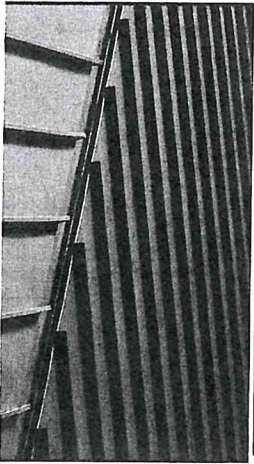


30 YEAR ARCHITECTURAL SHINGLES


COLOR = Weatherwood

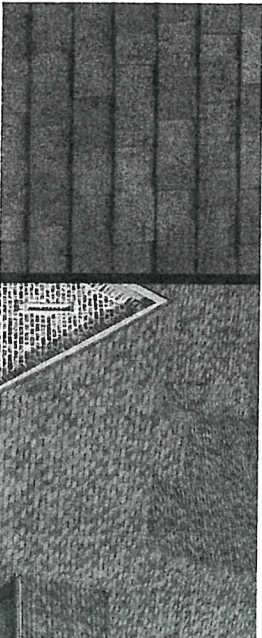

Garage Door=Wayne Dalton Charleston Style
9405 Door with Stockbridge impact glass

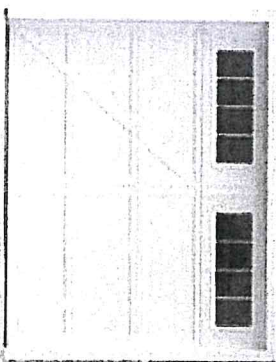

LOT # 106
PIN# 358-16-01-0003
COASTAL RESORT HOLDINGS LLC
256,980 Sq. Feet
5.90 Acres

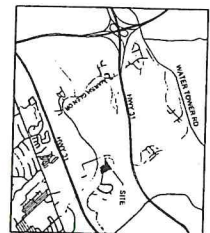

G3
ENGINEERING
P.O. BOX 2665
SAWLEYS ISLAND, SC 29585
PHONE: 843.237.1001
www.G3Engineering.org



3	REV BLDG LAYOUT - CR MORTON			MAX	9-26-17	
2	TEE OFF WATER SERVICE'S REMOVED - FRASH DETAIL			MAK	8-10-17	
1	REV PLR EHC COMMENTS			MAK	4-27-17	
NO.	REVISIONS			BY	DATE	

SHEET EXHIBIT