



[illegible]

D·R·HORTON **DHI**
NYSE
America's Builder

Copyright 2010, All Rights Reserved



ARCHITECTURAL GROUP
641.1895 in
704
641.8440 su
1144 Main Hwy
Waltham, North Carolina 28127
www.ubisoft.com

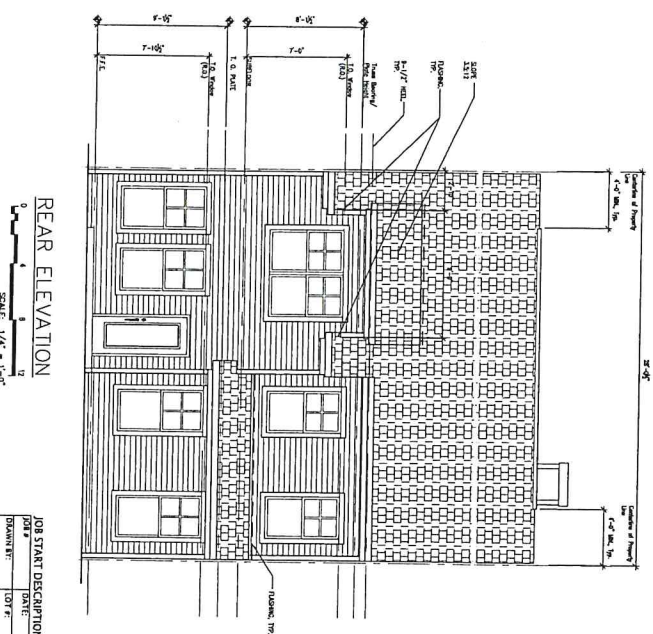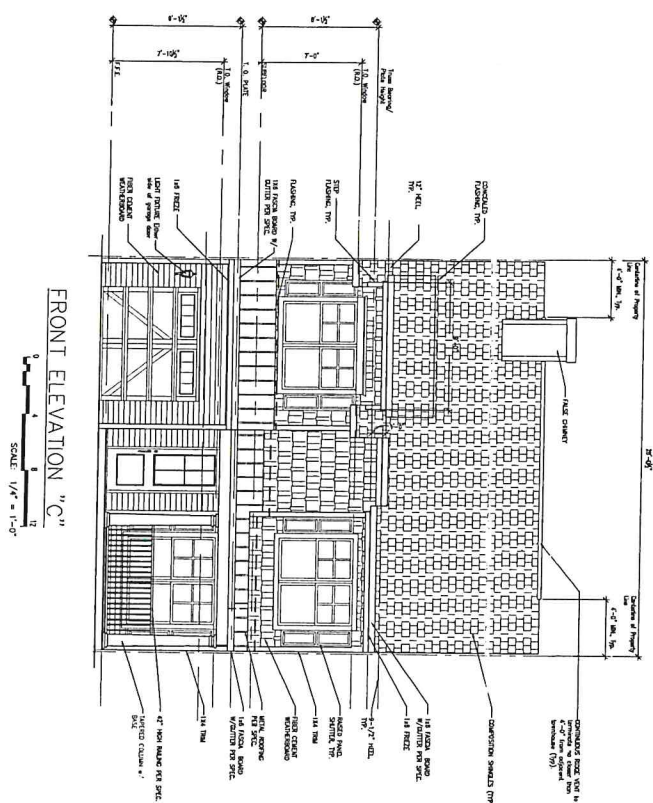

JOB START DESCRIPTION	
DATE	10/1/18
PROJECT NO.	2018-91
SHEET NUMBER	1.1

JOB START DESCRIPTION	
DATE	10/1/18
PROJECT NO.	2018-91
SHEET NUMBER	1.1

JOB START DESCRIPTION	
DATE	10/1/18
PROJECT NO.	2018-91
SHEET NUMBER	1.1


JOB START DESCRIPTION	
DATE	10/1/18
PROJECT NO.	2018-91
SHEET NUMBER	1.1


D-R HORTON
America's Builder

PHI
NYSE


URBAN

ARCHITECTURAL GROUP

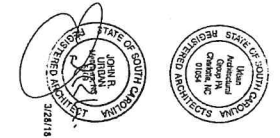


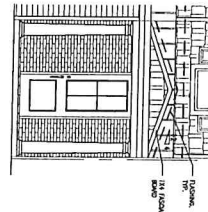

ELEVATION "D"
SCALE: 1/4" = 1'-0"

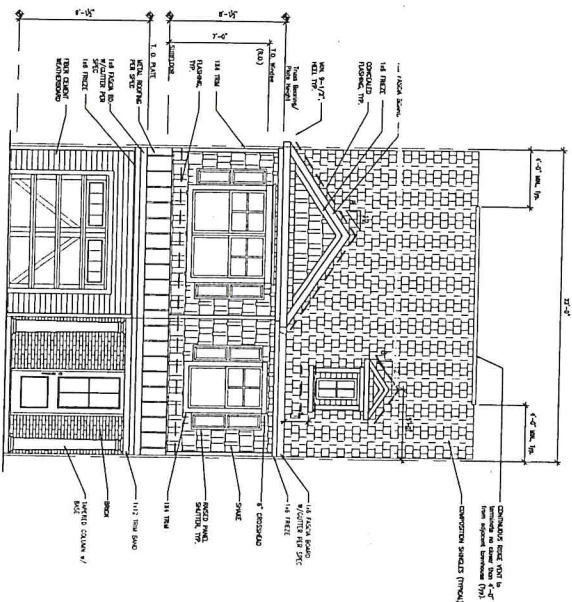

FRONT ELEVATION "C"
SCALE: 1/4" = 1'-0"

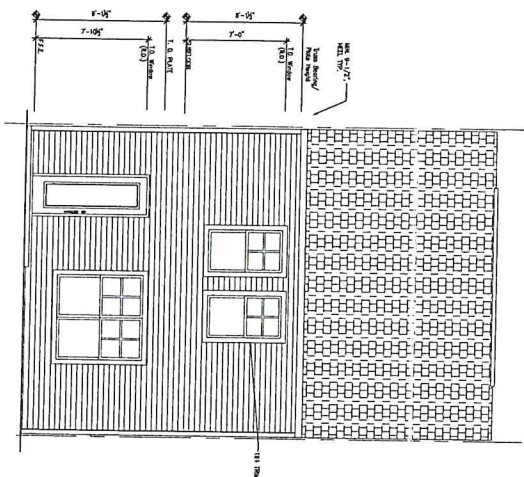

REAR ELEVATION
SCALE: 1/4" = 1'-0"



JOB START DESCRIPTION	
DATE	
DESIGNER	TOFF
CONSTRUCTION	
REVISION	

DATE: 1/21/11
PROJECT NO: 210-41
SHEET NUMBER


1.1

EXTERIOR
ELEVATIONS

AVIATOR

D-R-HORTON
America's Builder
DHI
NYSE

URBAN
ARCHITECTURAL GROUP
204 East 12th St.
1121 South Blvd.
Greenville, SC 29615
864.234.1234
www.urbanarchitect.com

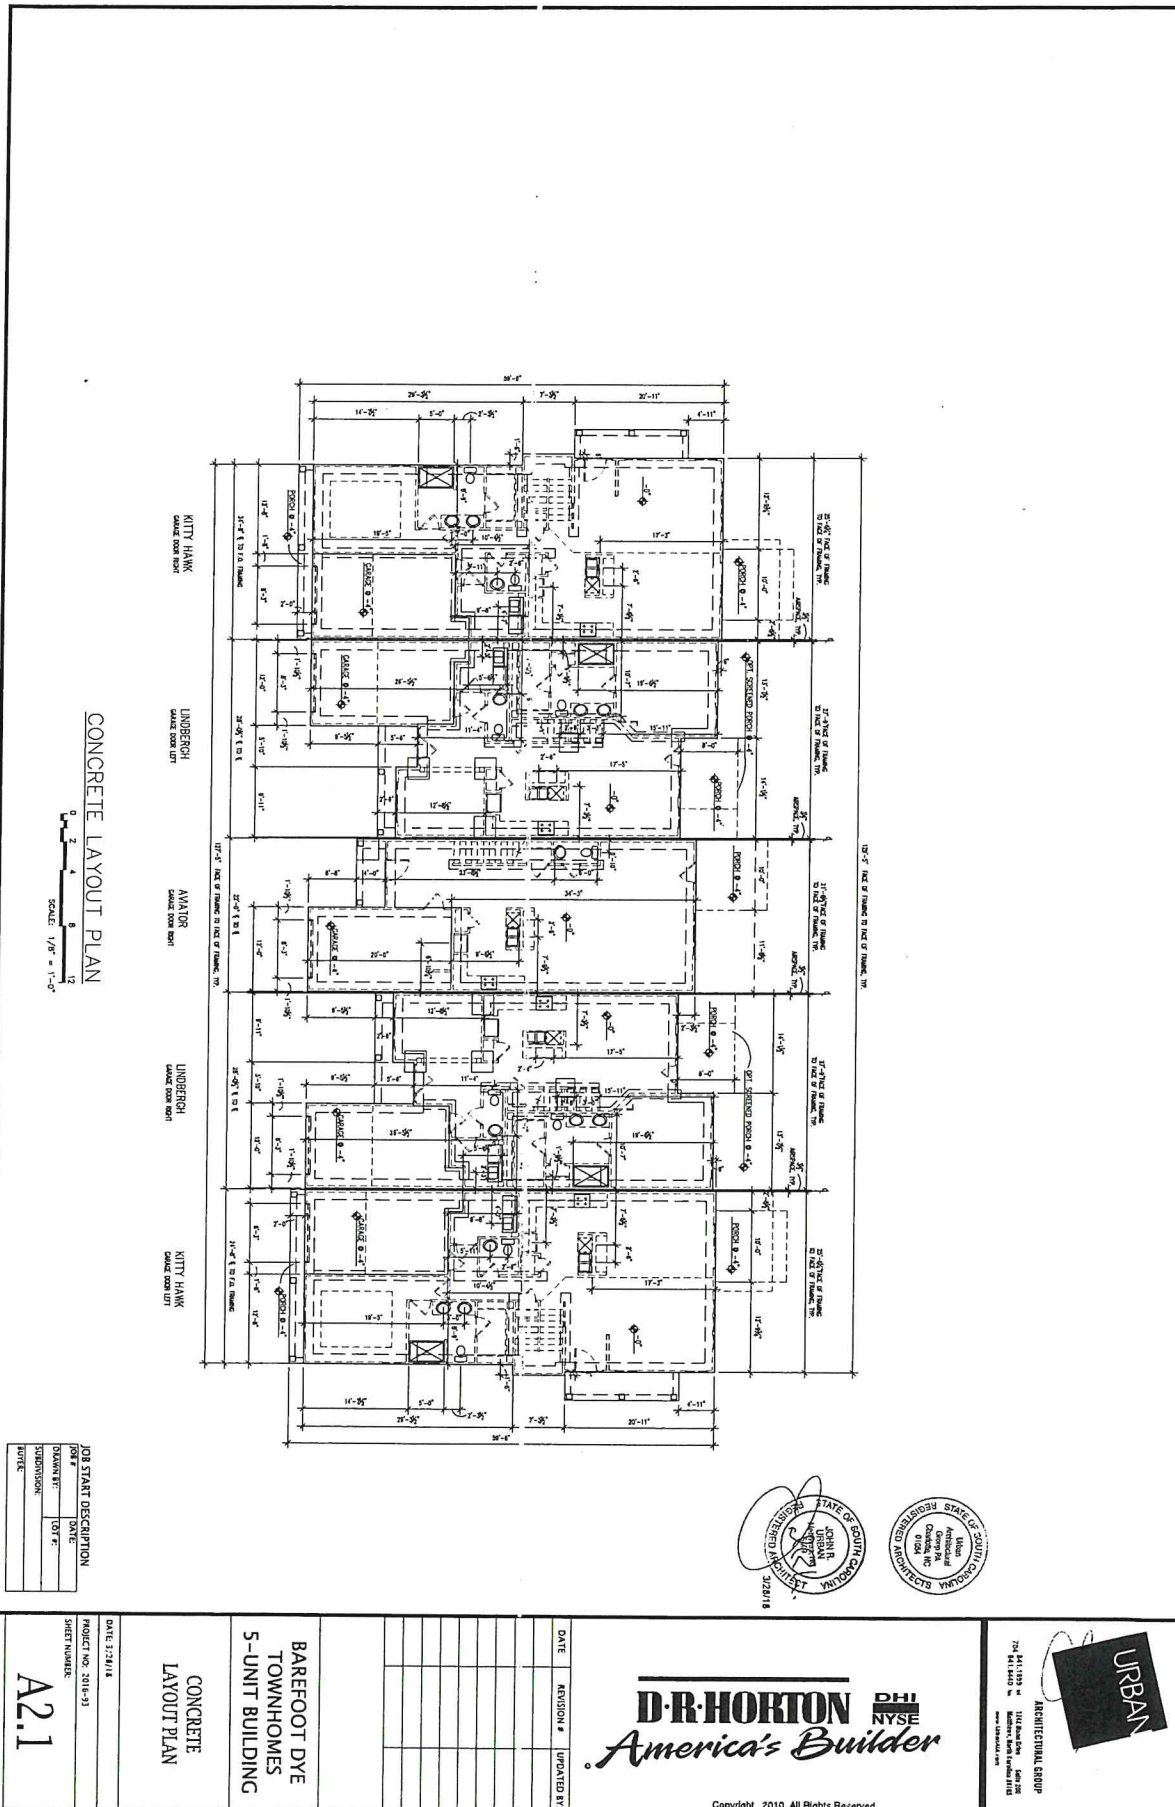

JOB START DESCRIPTION	
DATE	
DESIGNER	TO: F.
STATIONING	
REVISION	

DATE: 12/14/18
PROJECT NO: 2018-13
SHEET NUMBER
A2.1

CONCRETE
LAYOUT PLAN

BARFOOT DYE
TOWNHOMES
5-UNIT BUILDING

DATE	REVISION #	UPDATED BY:


D-R HORTON **DH NYSE**
America's Builder

Copyright 2010, All Rights Reserved


URBAN


ARCHITECTURAL GROUP
704 S. 11TH ST.
SUITE 100
DENVER, CO 80202
303.733.1111
WWW.URBANARCHITECTS.COM



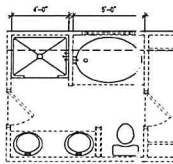

JOB START DESCRIPTION	
JOB #	DATE
DRAWN BY:	LOT #:
SUBDIVISION:	
BUTLE:	

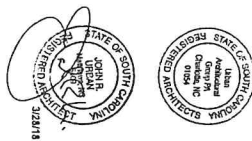[illegible]

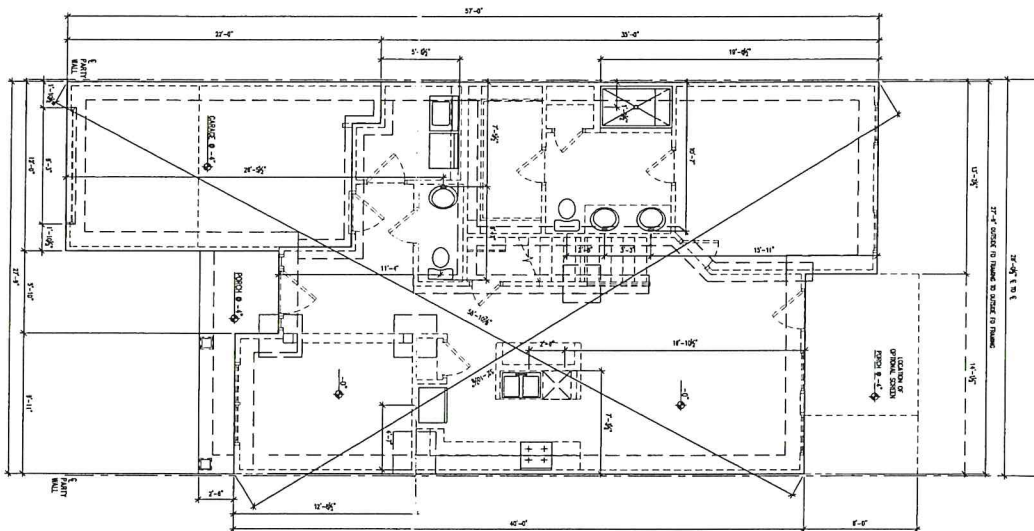[illegible]

Copyright 2010. All Rights Reserved





D·R·HORTON
America's Builder



DATE

REVISION #

UPDATED BY

DATE: 1/29/18

PROJECT NO: 2016-93


SHEET NUMBER

AVIATOR

CONCRETE
LAYOUT PLAN

2.1

Copyright 2010, All Rights Reserved

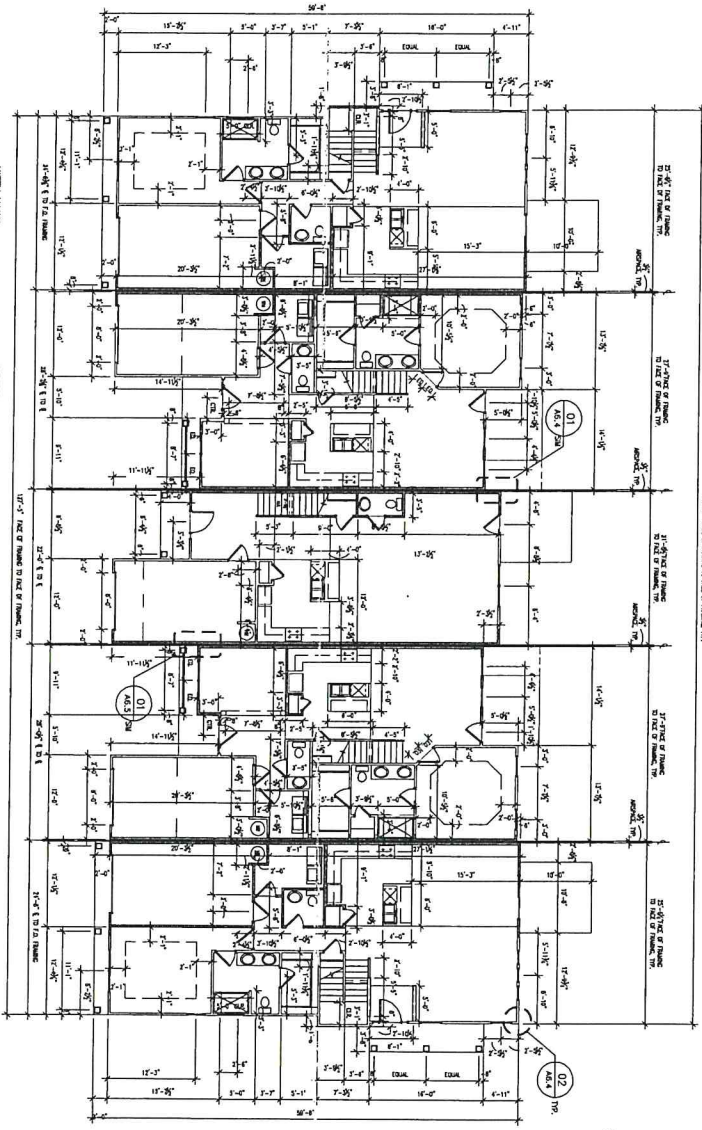

FIRST FLOOR PLAN

SCALE: 1/8" = 1'-0"

JOB START DESCRIPTION	
DATE	DATE
DESIGNER	DATE
REVISION	DATE
TITLE	

DATE: 1/28/11
PROJECT NO: 2011-01
SHEET NUMBER:
A3.1

FIRST FLOOR PLAN

BALEFOOT DYE
TOWNHOMES
5-UNIT BUILDING


DATE	REVISION #	UPDATED BY

D.R. HORTON
America's Builder

Copyright 2010, All Rights Reserved



URBAN
ARCHITECTURAL GROUP
724 441-1222
1115 Main Street
Columbia, SC 29201
www.urbandesign.com

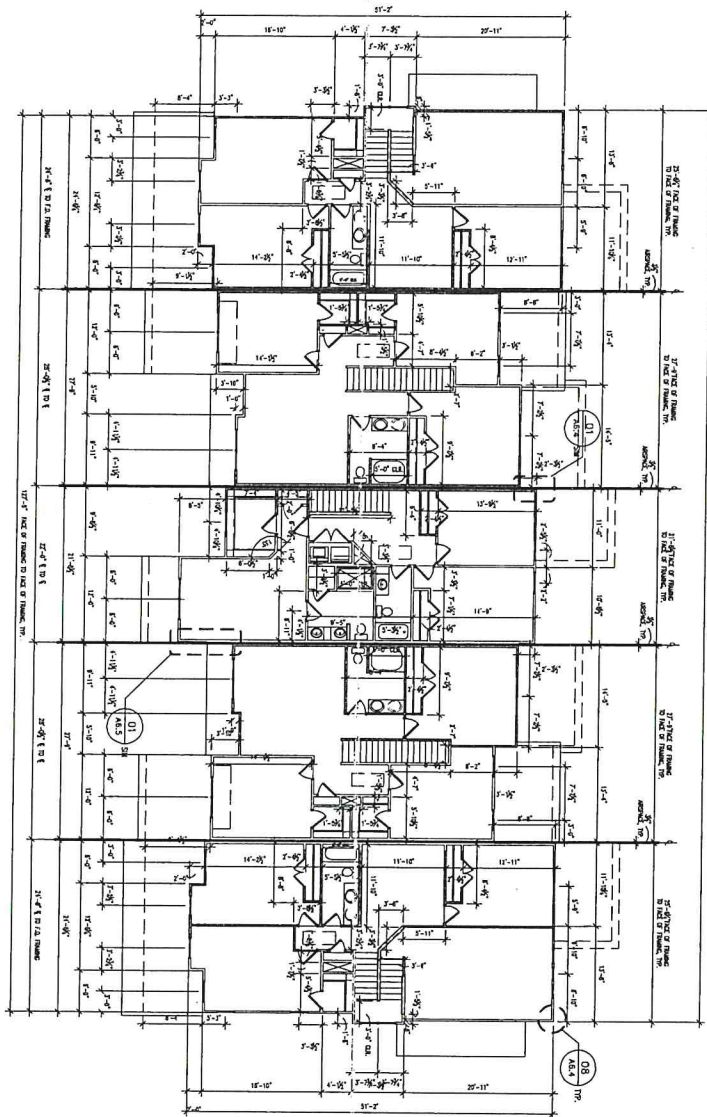

SECOND FLOOR PLAN

0 3 4 8 12
SCALE 1/8" = 1'-0"

JOB START DESCRIPTION	
DATE	12/11/18
DRAWN BY	LOF
STATIONING	
REVISION	

A3.2

SECOND FLOOR PLAN

BAREFOOT DYE
TOWNHOMES
5-UNIT BUILDING

DATE	REVISION #	REVISION BY





D-R HORTON **PHI NYSE**
America's Builder

Copyright 2010, All Rights Reserved

724-111-1111
724-111-1111
724-111-1111
724-111-1111

ARCHITECTURAL GROUP



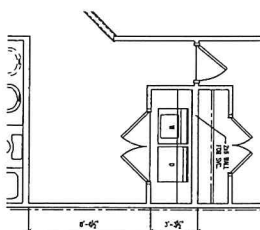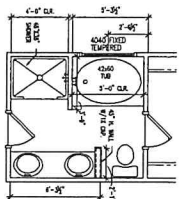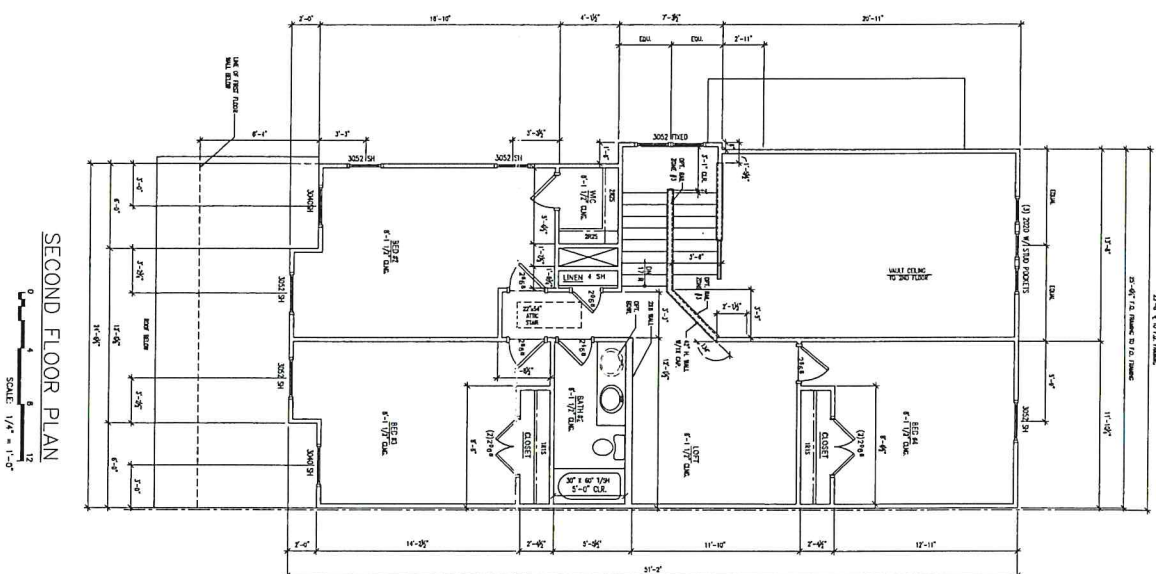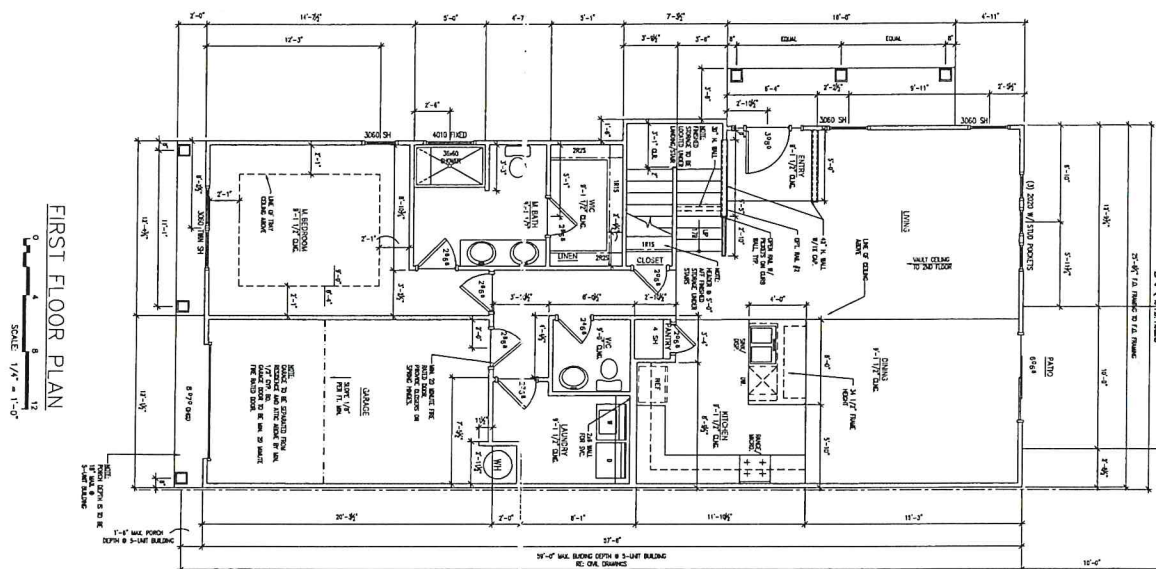

GENERAL NOTES AND LEGEND

1. PLATE HEIGHTS ARE AT 9'-1 1/2" @ 1ST FLOOR AND 8'-1 1/2" @ 2ND FLOOR.
2. ALL DOORS TO BE CENTERED IN OPENING, OR OFFSET FROM CORNER 4"

JOB #		DATE:
DRAWN BY:	LOT #:	
SUBDIVISION:		
BUYER:		

**FIRST AND SECOND
FLOOR PLANS**

DATE 3/28/13
PROJECT NO. 2016-93
SHEET NUMBER

3.1


[illegible]

D·R·HORTON **DHI**
NYSE
America's Builder

Copyright 2010, All Rights Reserved




SCREENED PORCH ELECTRICAL PLAN

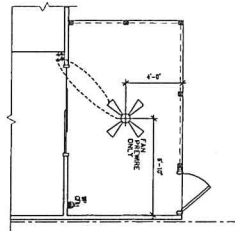


0 4 8 12
SCALE: 1/4" = 1'-0"

SCREENED PORCH FLOOR PLAN

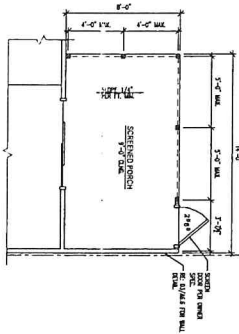


SIDE ELEVATION

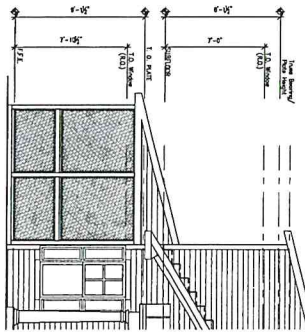

0 4 8 12
SCALE: 1/4" = 1'-0"

REAR ELEVATION

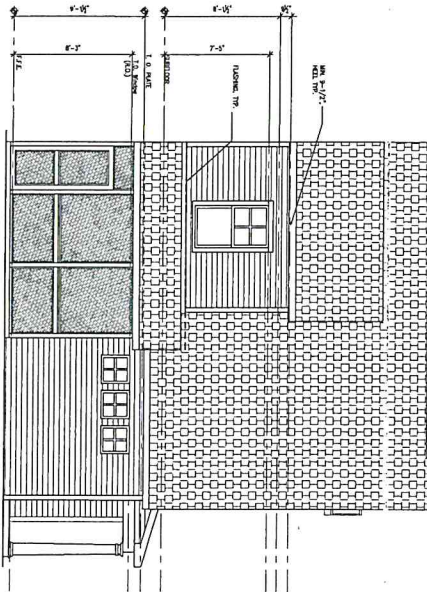

JOB START DESCRIPTION	
JOB #	DATE:
DIAMOND BY:	LOT #:
SUBDIVISION:	
BUYER:	

DATE: 3/28/18
PROJECT NO: 2016-93
SHEET NUMBER:
3.2


[illegible]

D·R·HORTON **DHI**
NYSE
America's Builder

Copyright 2010, All Rights Reserved




ANCHIECTICULAR GROUP
 841.1899 nf 1143 Mason Drive Suite 200
 704 841.8440 Macomber, North Carolina 27122
 www.anchiectular.com

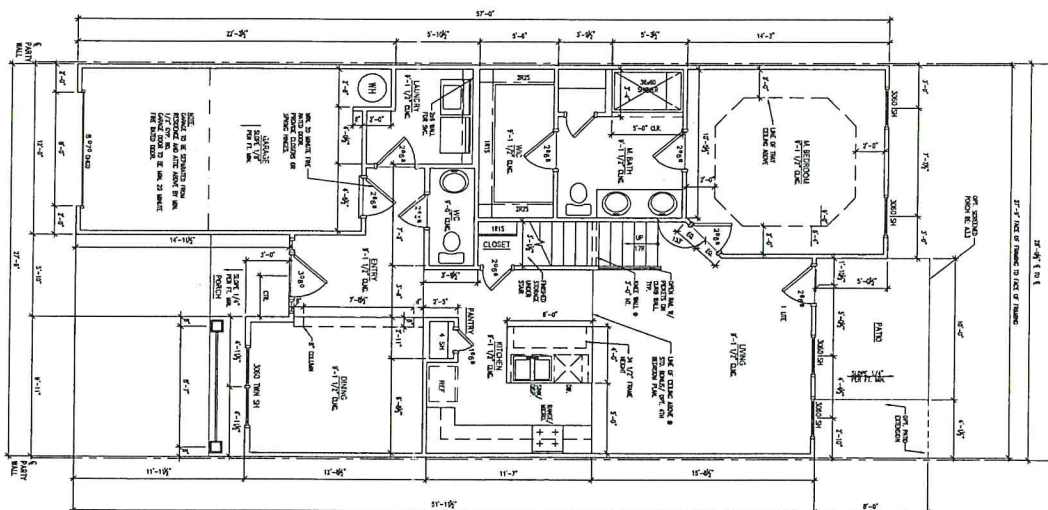

FIRST FLOOR PLAN




GENERAL NOTES AND LEGEND

1. FLOOR HEIGHTS ARE AT 9'-1 1/2" @ 1ST FLOOR AND 8'-1 1/2" @ 2ND FLOOR.
2. ALL DOORS TO BE CENTERED IN OPENING, OR OFFSET FROM CORNER 4".

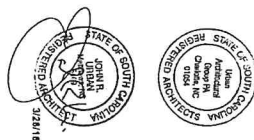

JOB START DESCRIPTION	
JOB #	DATE
DRAWN BY:	LOT #
SUBDIVISION:	
BUYER:	

[illegible]

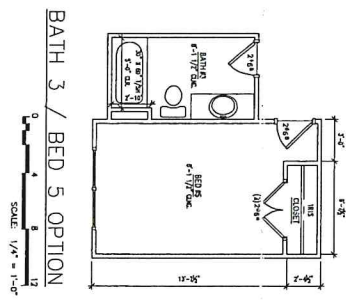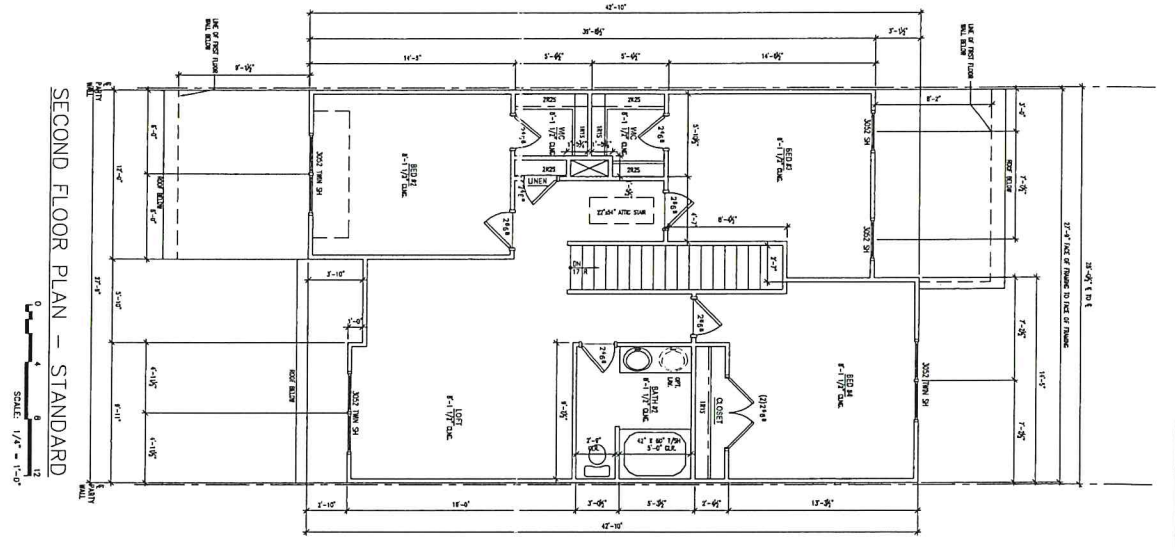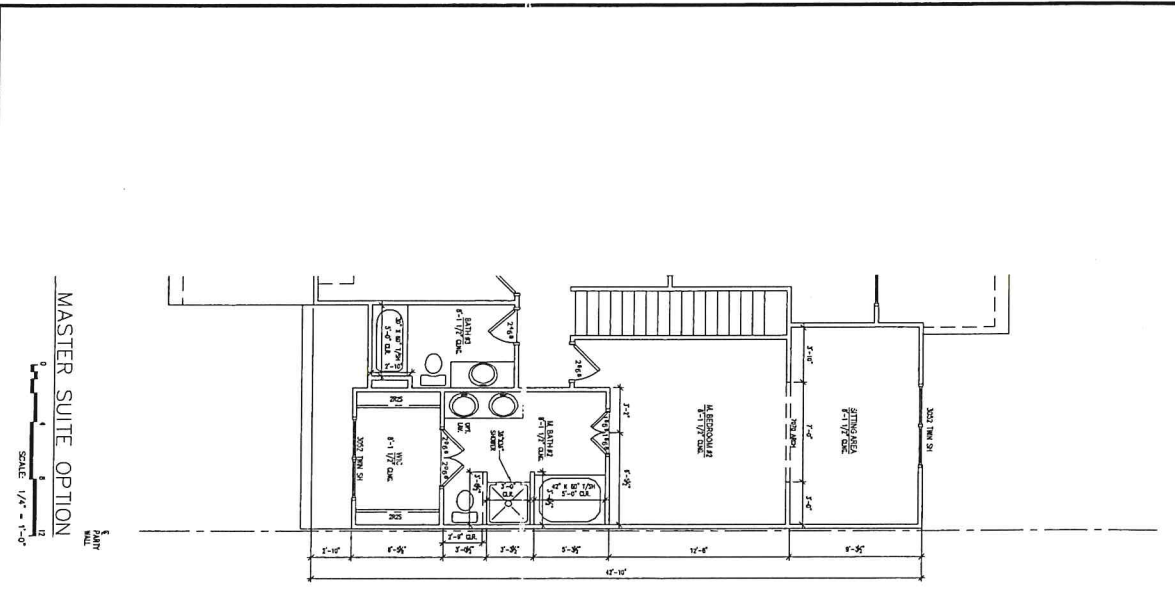

- GENERAL NOTES AND LEGEND**
1. FLOOR HEIGHTS ARE AT F-1, F-2, F-3 & F-4
 2. ALL ROOMS TO BE FINISHED IN GRAY.
 3. SEE NOTES FOR FINISHES.



JOB START DESCRIPTION	
OWNER	DATE
DESIGNER	DATE
CONSTRUCTION	DATE
REVISION	DATE

3.2

SECOND FLOOR PLAN

LINDERBACH

D.R. HORTON PHI NYSE

America's Builder

Copyright 2010, All Rights Reserved

URBAN

ARCHITECTURAL GROUP

704.441.1234

1000 West 10th Street, Suite 1000

Fort Lauderdale, FL 33304